




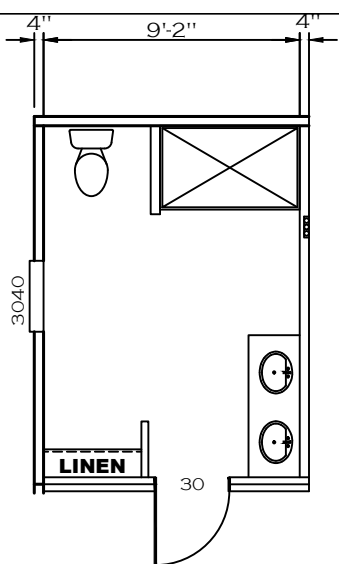



PRIMARY BATH 60" SHOWER ONLY

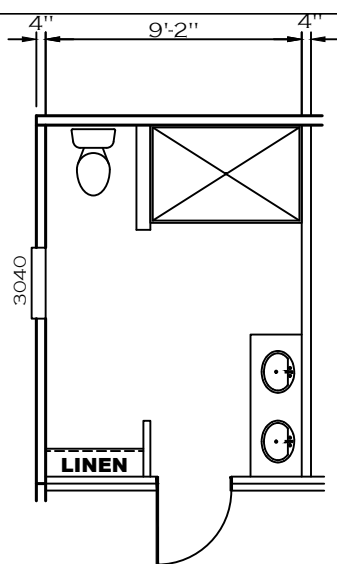

OPT. PRIMARY BATH 65" SHOWER

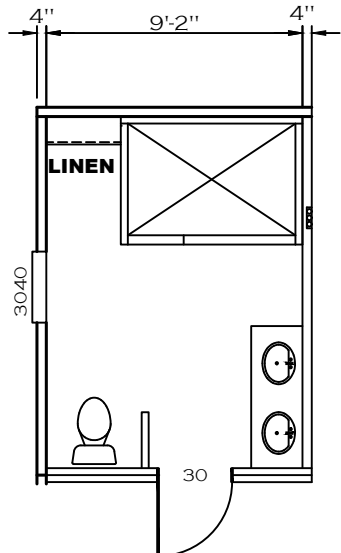


PRIMARY BATH 72" SHOWER ONLY

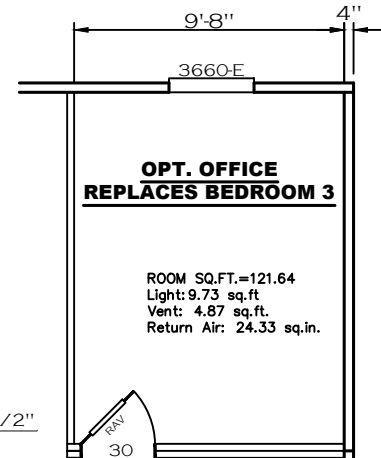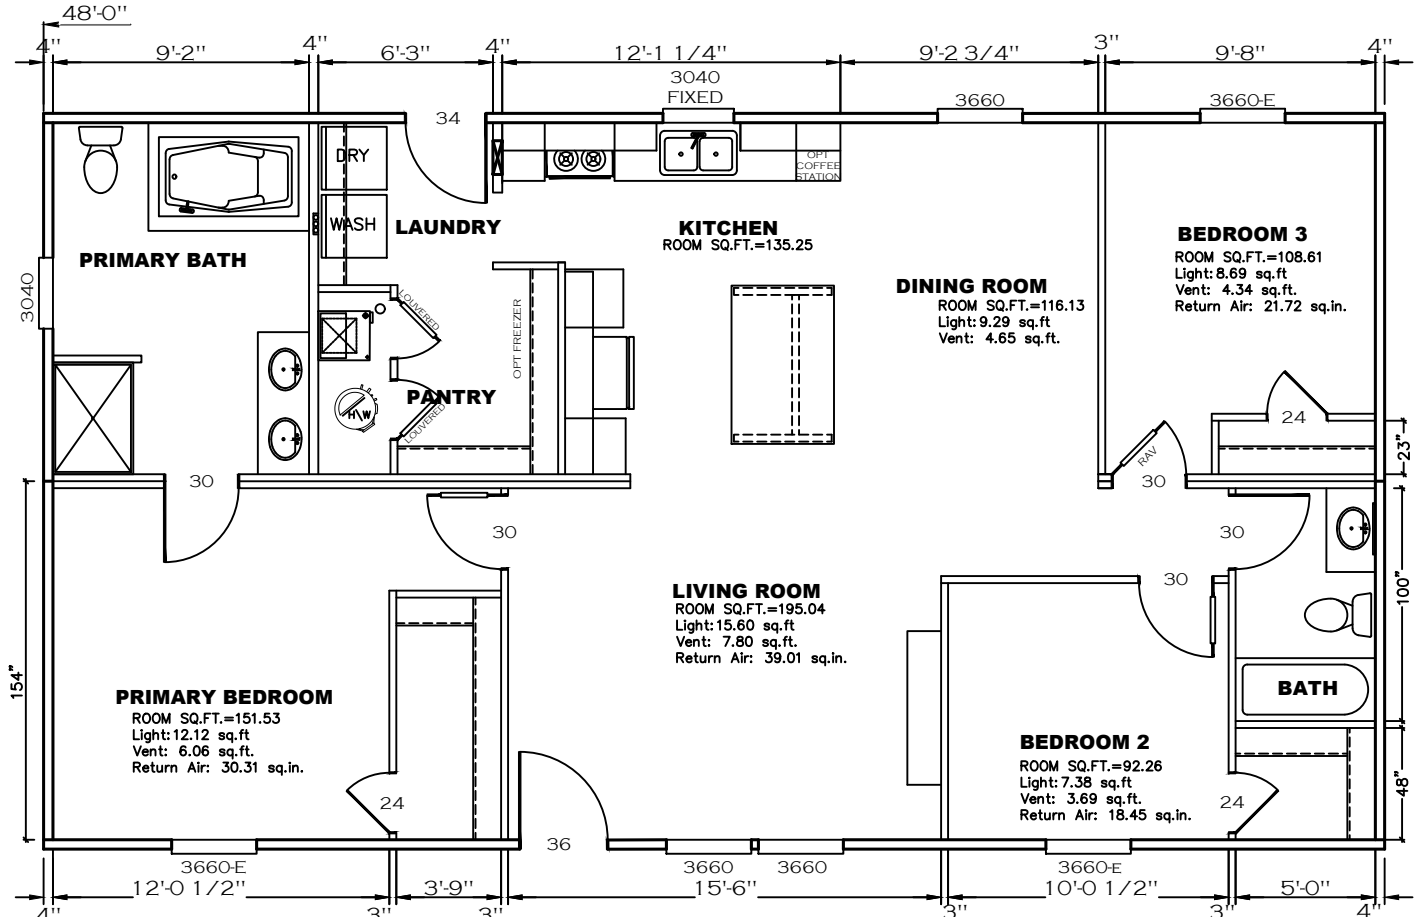

OPT. DINING ROOM SGD

SHEET: FP	FLOOR PLAN		Clayton - 934 1420 Mountain Rd, Andersonville, TN 37705 PH: 865.494.7800 FAX: 865.494.0243	HILBORN, WERNER, CARTER, AND ASSOCIATES, INC. 1627 SOUTH MYRTLE AVE. CLEARWATER, FL. 33756	DRAWING #: 34M400-FP MODEL #: MTN28483A DATE: 4/29/2026	SCALE: N.T.S. MODEL: MOUNTAINEER 48 (28'x48') SERIES: MOUNTAINEER PRODUCT DESIGNER: BRIAN K RIFFEY	STD PLAN "CONDITIONED": 1,264 FT² REV. BY: REV. DATE:
-----------	------------	--	--	--	---	---	---

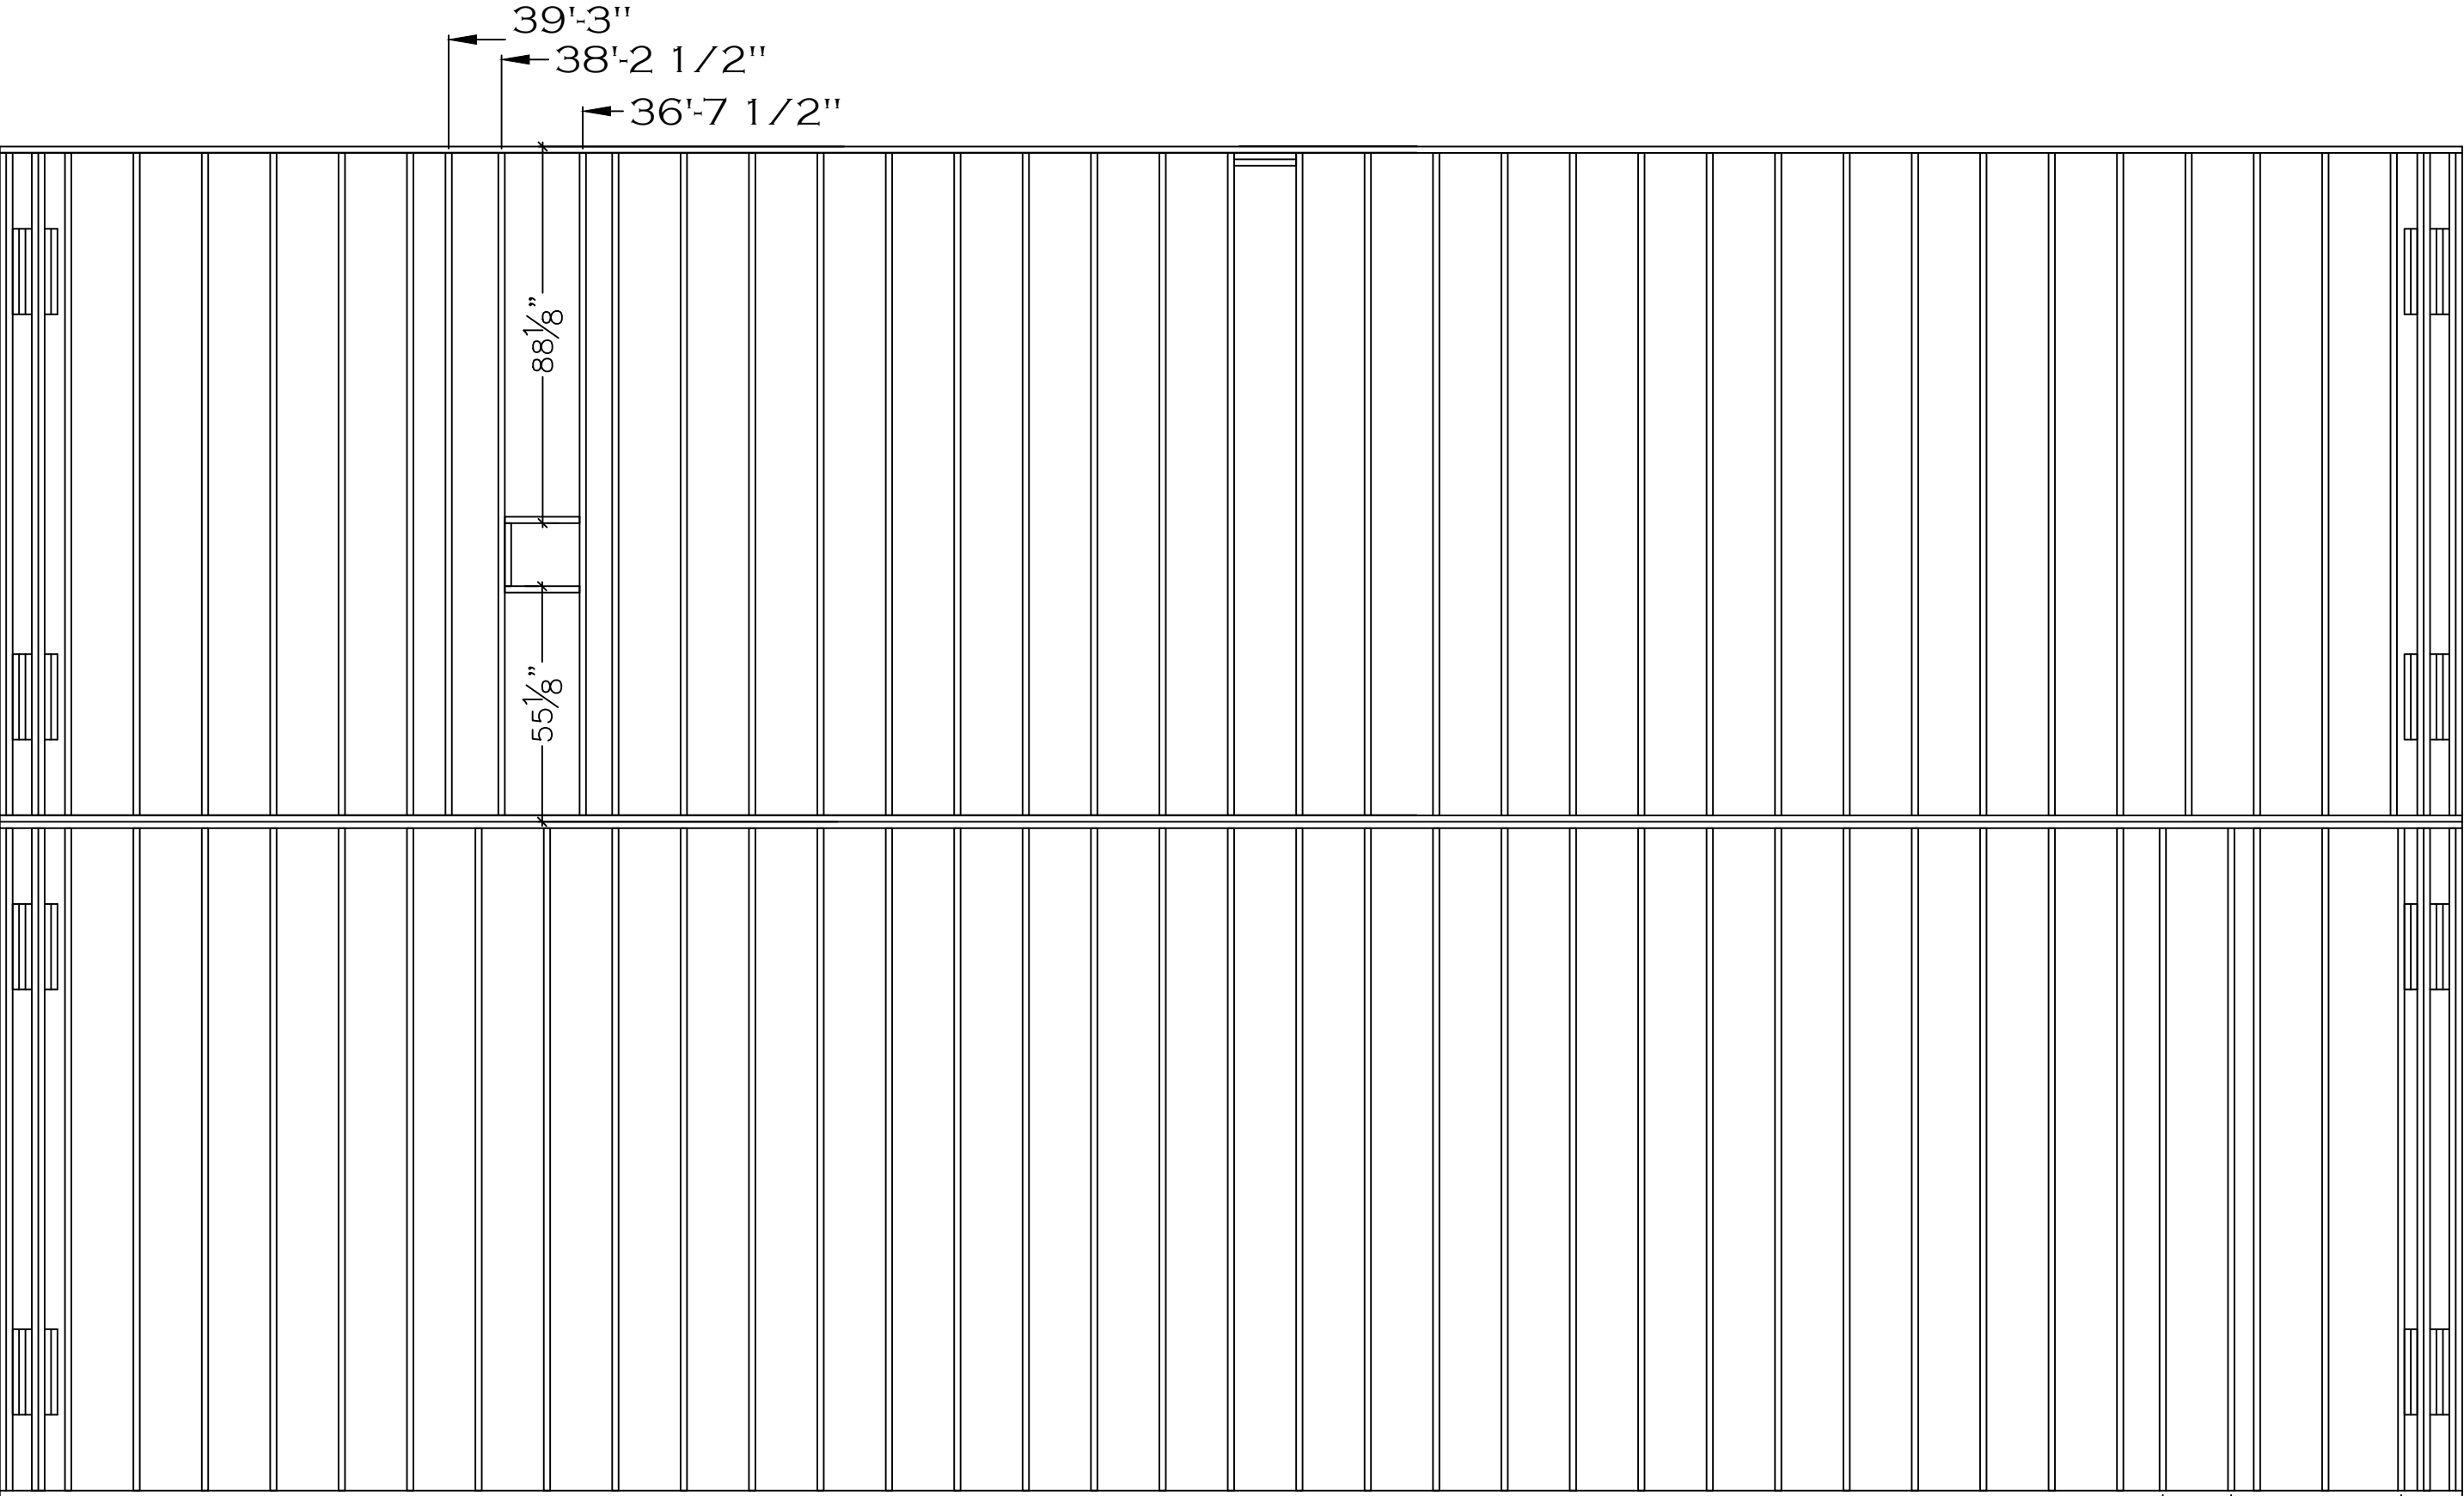


4'-6" 1'-2 1/4"
5'-10"


REV #	DATE	DESCRIPTION	SHEET:	FLOOR JOIST PLAN		DRAWING # 34M400	MODEL: MOUNTAINEER 48 (28'x48')	STD PLAN *CONDITIONED*: 1,264 FT²
-	-	-	FJIG			MODEL # MTN28483A	SERIES: MOUNTAINEER	REV. BY:
						DATE: 4/29/2026	SCALE: N.T.S.	PRODUCT DESIGNER: BRIAN K. RIFFEY

Clayton Clayton - 934
1420 Mountain Rd, Andersonville, TN 37705
PH: 865.494.7800 FAX: 865.494.0243


HILBORN, WERNER, CARTER,
AND ASSOCIATES, INC.
1627 SOUTH MYRTLE AVE.
CLEARWATER, FL. 33756

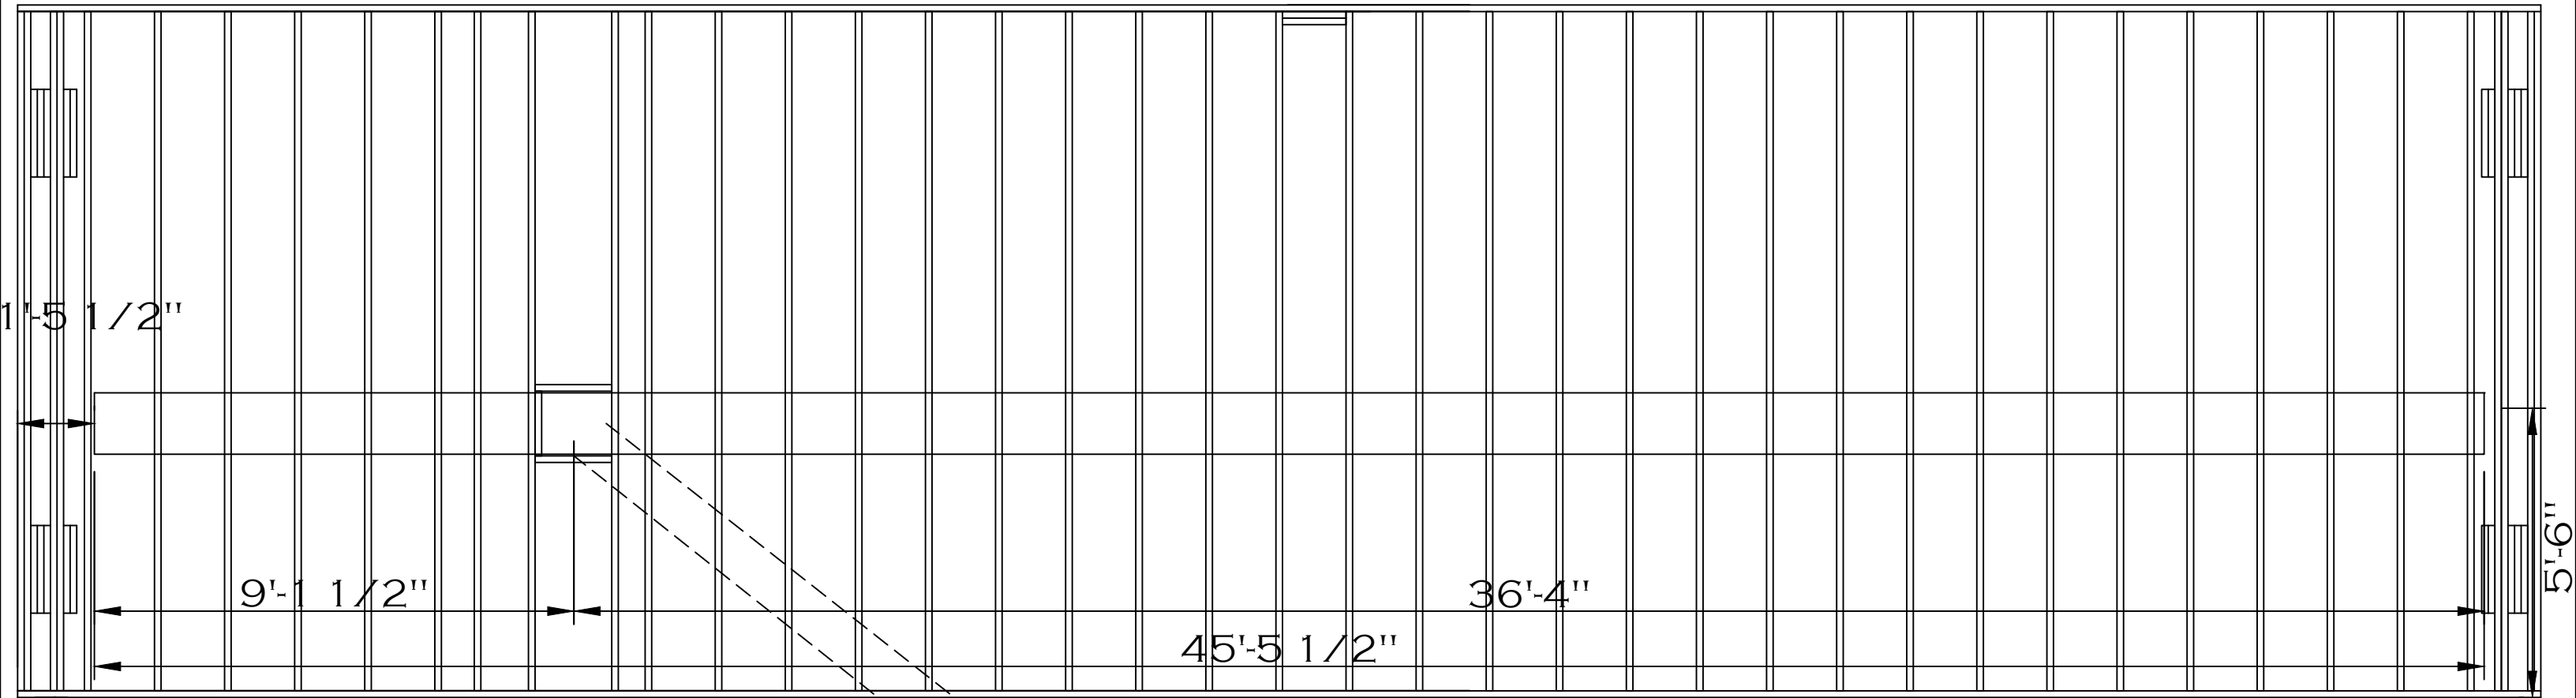

SHEET: FJIG	HEAT DUCK B HALF	 Clayton - 934 1420 Mountain Rd, Andersonville, TN 37705 PH: 865.494.7800 FAX: 865.494.0243	HILBORN, WERNER, CARTER, AND ASSOCIATES, INC. 1627 SOUTH MYRTLE AVE. CLEARWATER, FL. 33756	DRAWING #: 34M400		MODEL: MOUNTAINEER 48 (28'x48')	STD PLAN "CONDITIONED": 1,264 FT²
				MODEL #: MTN28483A		SERIES: MOUNTAINEER	REV. BY:
				DATE: 4/29/2026	SCALE: N.T.S.	PRODUCT DESIGNER: BRIAN K. RIFFEY	REV. DATE:

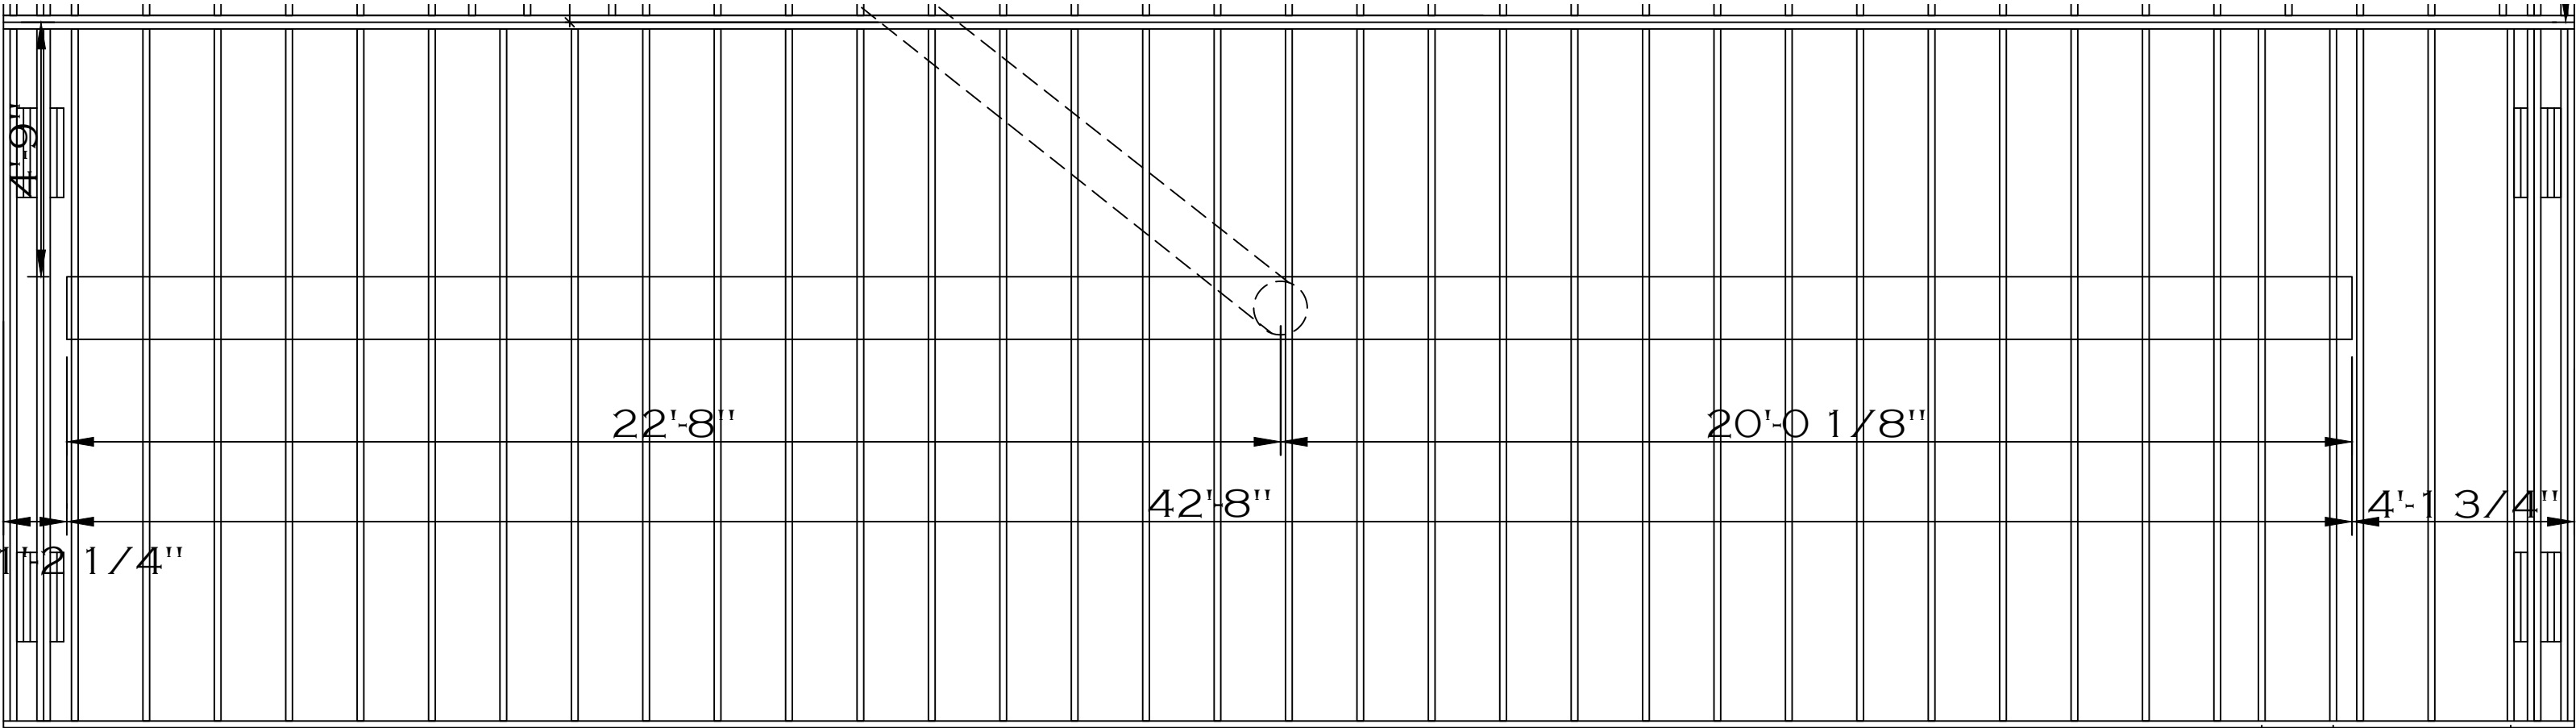

SHEET: FJIG	HVAC DUCK A HALF	 Clayton - 934 1420 Mountain Rd, Andersonville, TN 37705 PH: 865.494.7800 FAX: 865.494.0243	HILBORN, WERNER, CARTER, AND ASSOCIATES, INC. 1627 SOUTH MYRTLE AVE. CLEARWATER, FL. 33756	DRAWING #: 34M400		MODEL: MOUNTAINEER 48 (28'x48')	STD PLAN "CONDITIONED": 1,264 FT²
				MODEL #: MTN28483A		SERIES: MOUNTAINEER	
				DATE: 4/29/2026	SCALE: N.T.S.	PRODUCT DESIGNER: BRIAN K. RIFFEY	

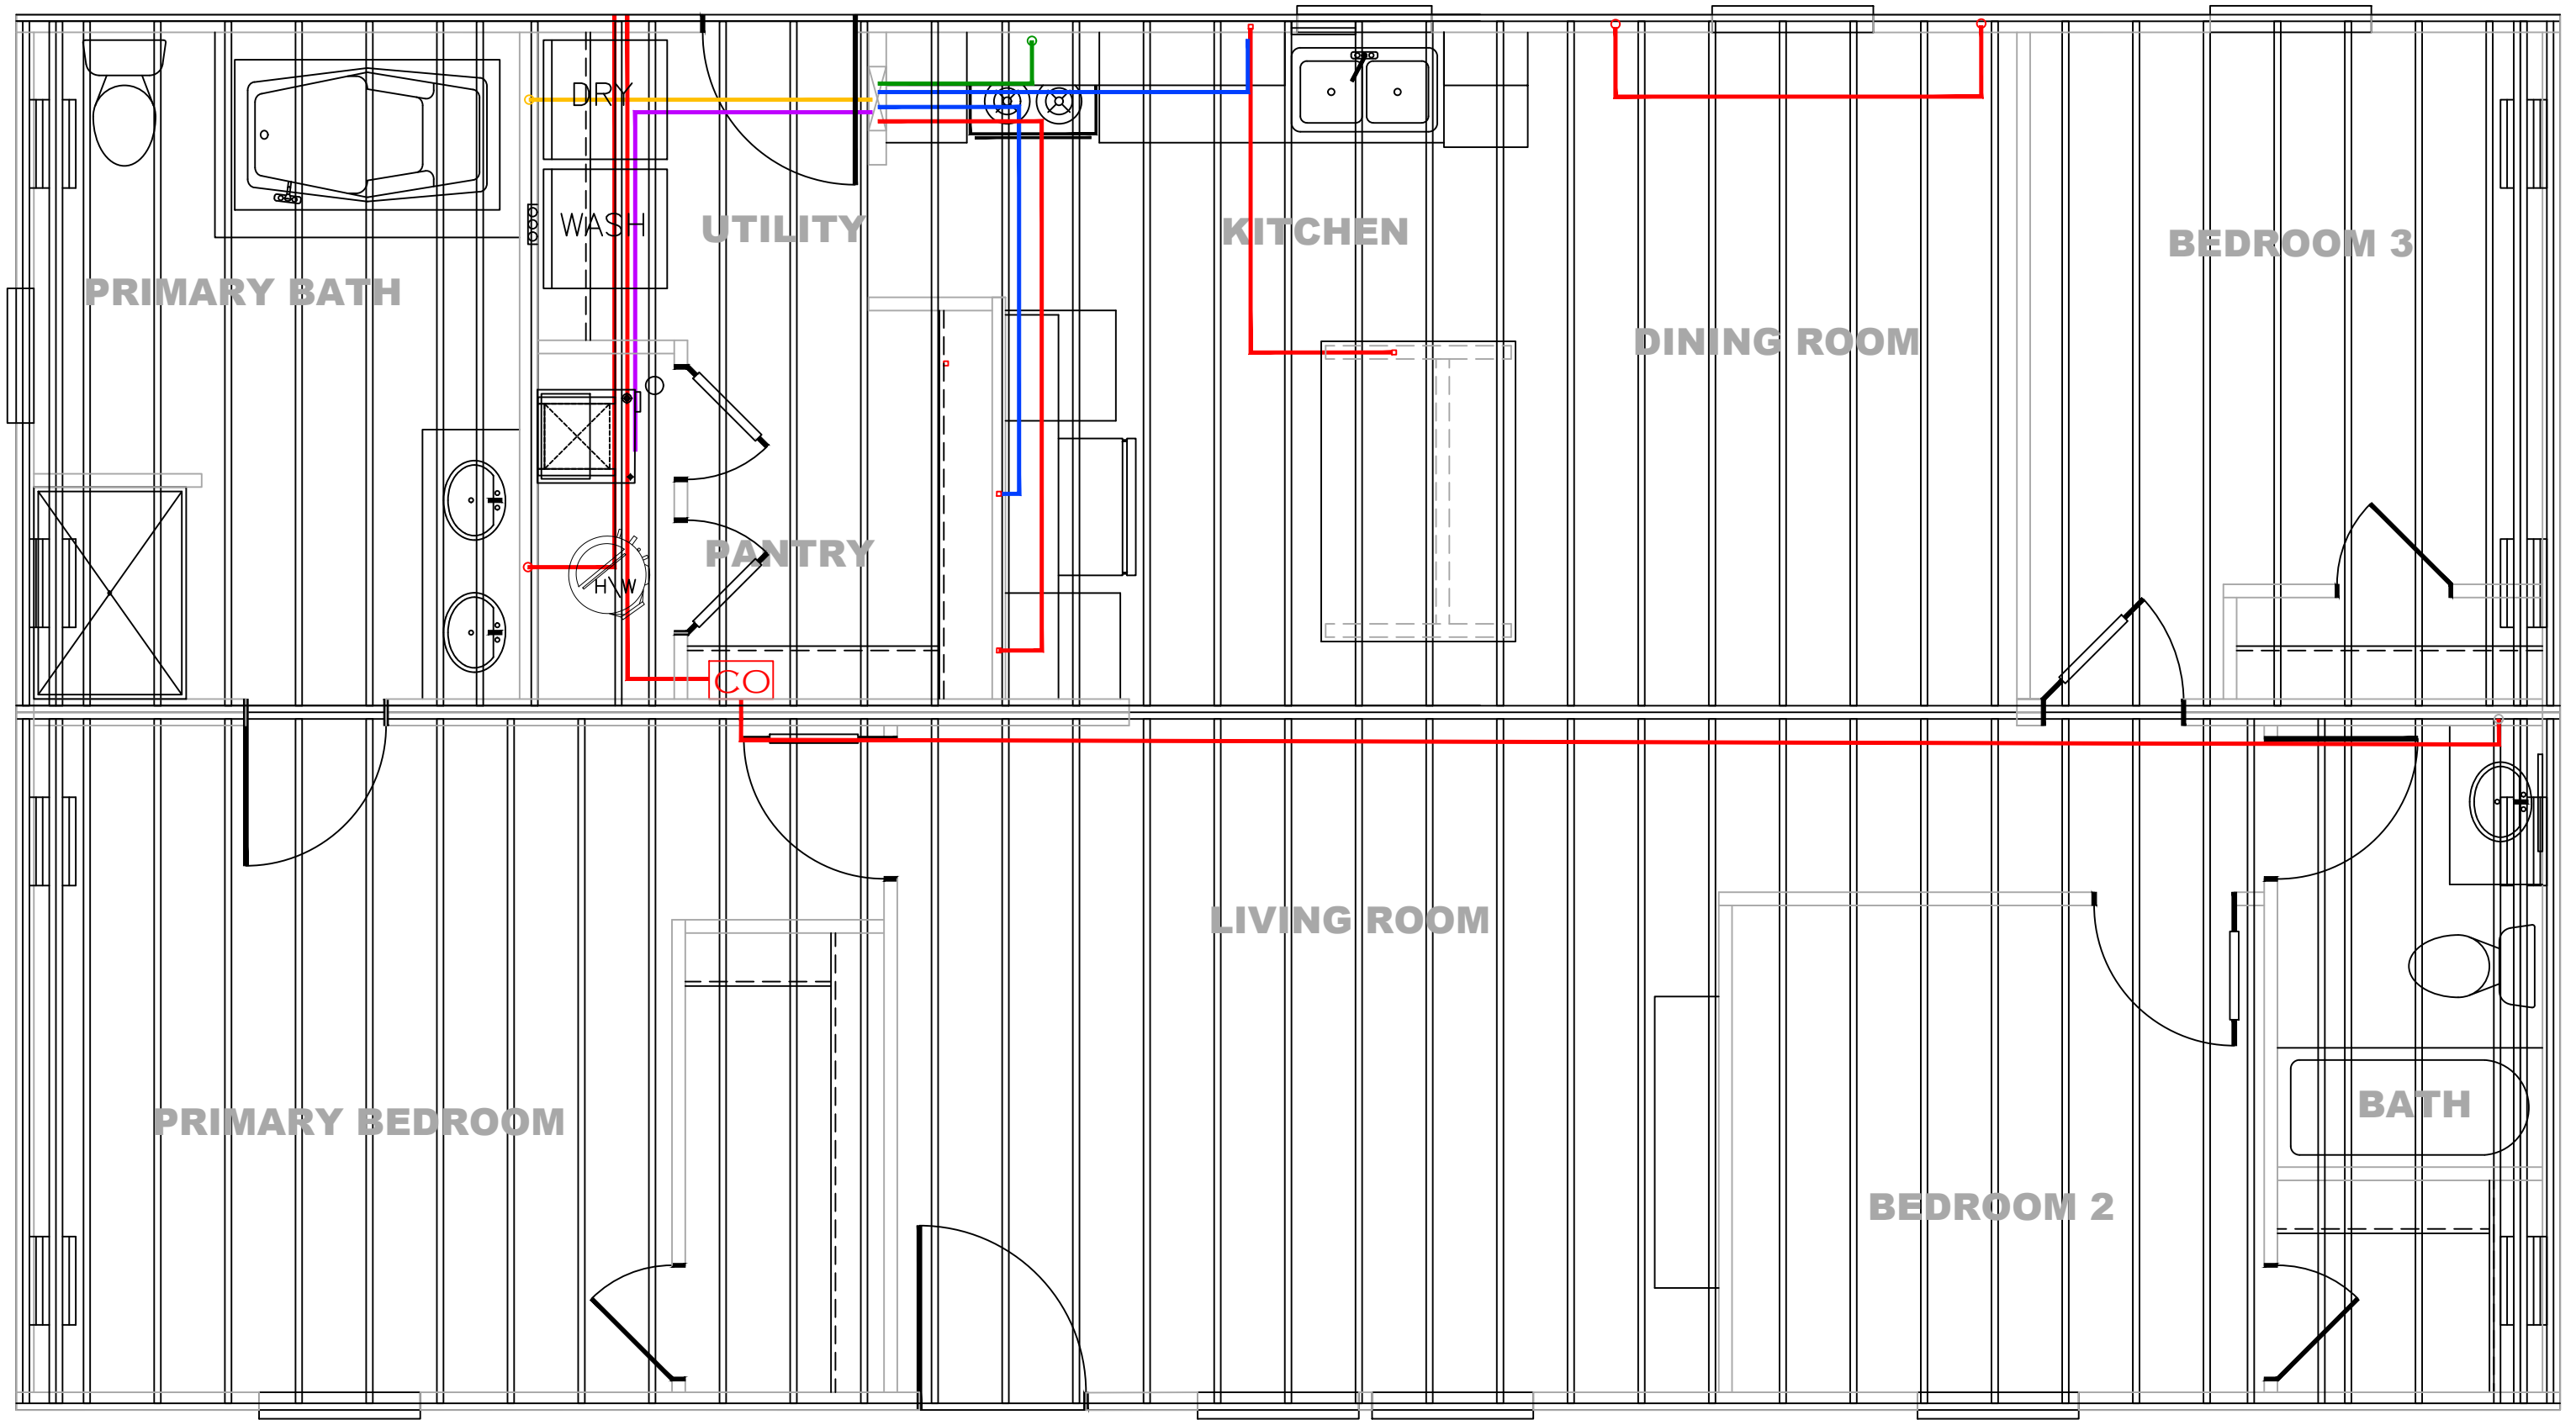

- = GFI (12-2)
- = RANGE
- = FURNACE
- = DRYER
- = WATER HEATER
- = DISHWASHER (D/W)
- = RANGE HOOD (14-2)
- MC = METER CENTER DROP

REV #	DATE	DESCRIPTION

SHEET:

FJIG

FLOOR JOIST
ELECTRICAL PLAN







Clayton - 934
1420 Mountain Rd, Andersonville, TN 37705
PH: 865.494.7800 FAX: 865.494.0243

HILBORN, WERNER, CARTER,
AND ASSOCIATES, INC.
1627 SOUTH MYRTLE AVE.
CLEARWATER, FL. 33756

DRAWING # 34M400	SCALE: N.T.S.
MODEL # MTN28483A	
DATE: 4/29/2026	

MODEL: MOUNTAINEER 48 (28'x48')	
SERIES: MOUNTAINEER	
PRODUCT DESIGNER: BRIAN K RIFFEY	


STD PLAN "CONDITIONED": 1,264 FT²
REV. BY:
REV. DATE:

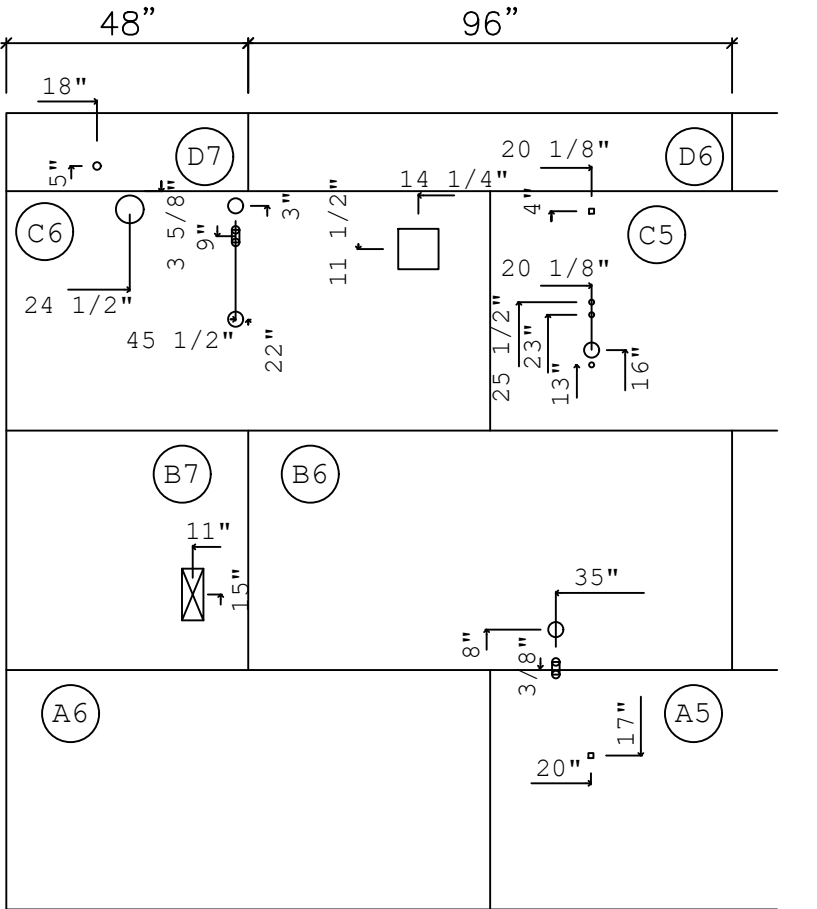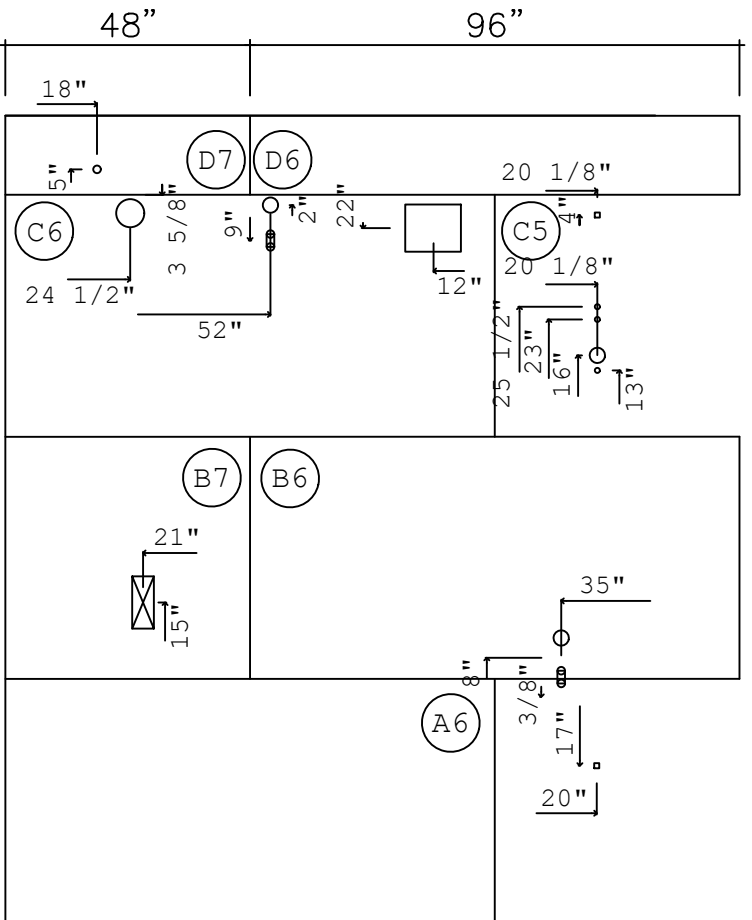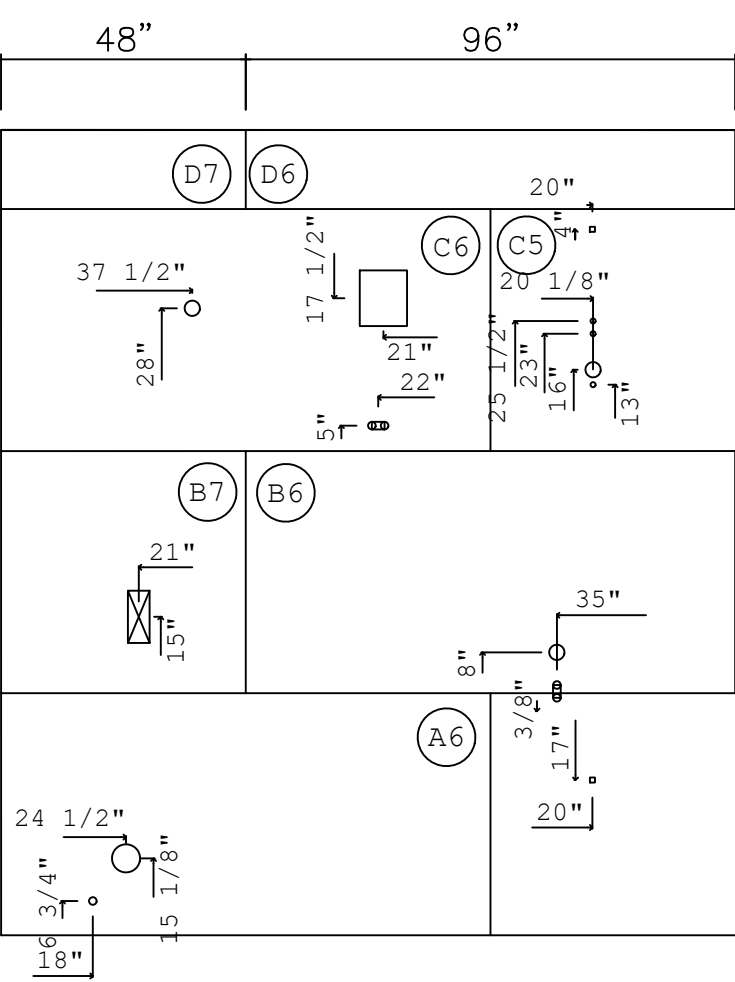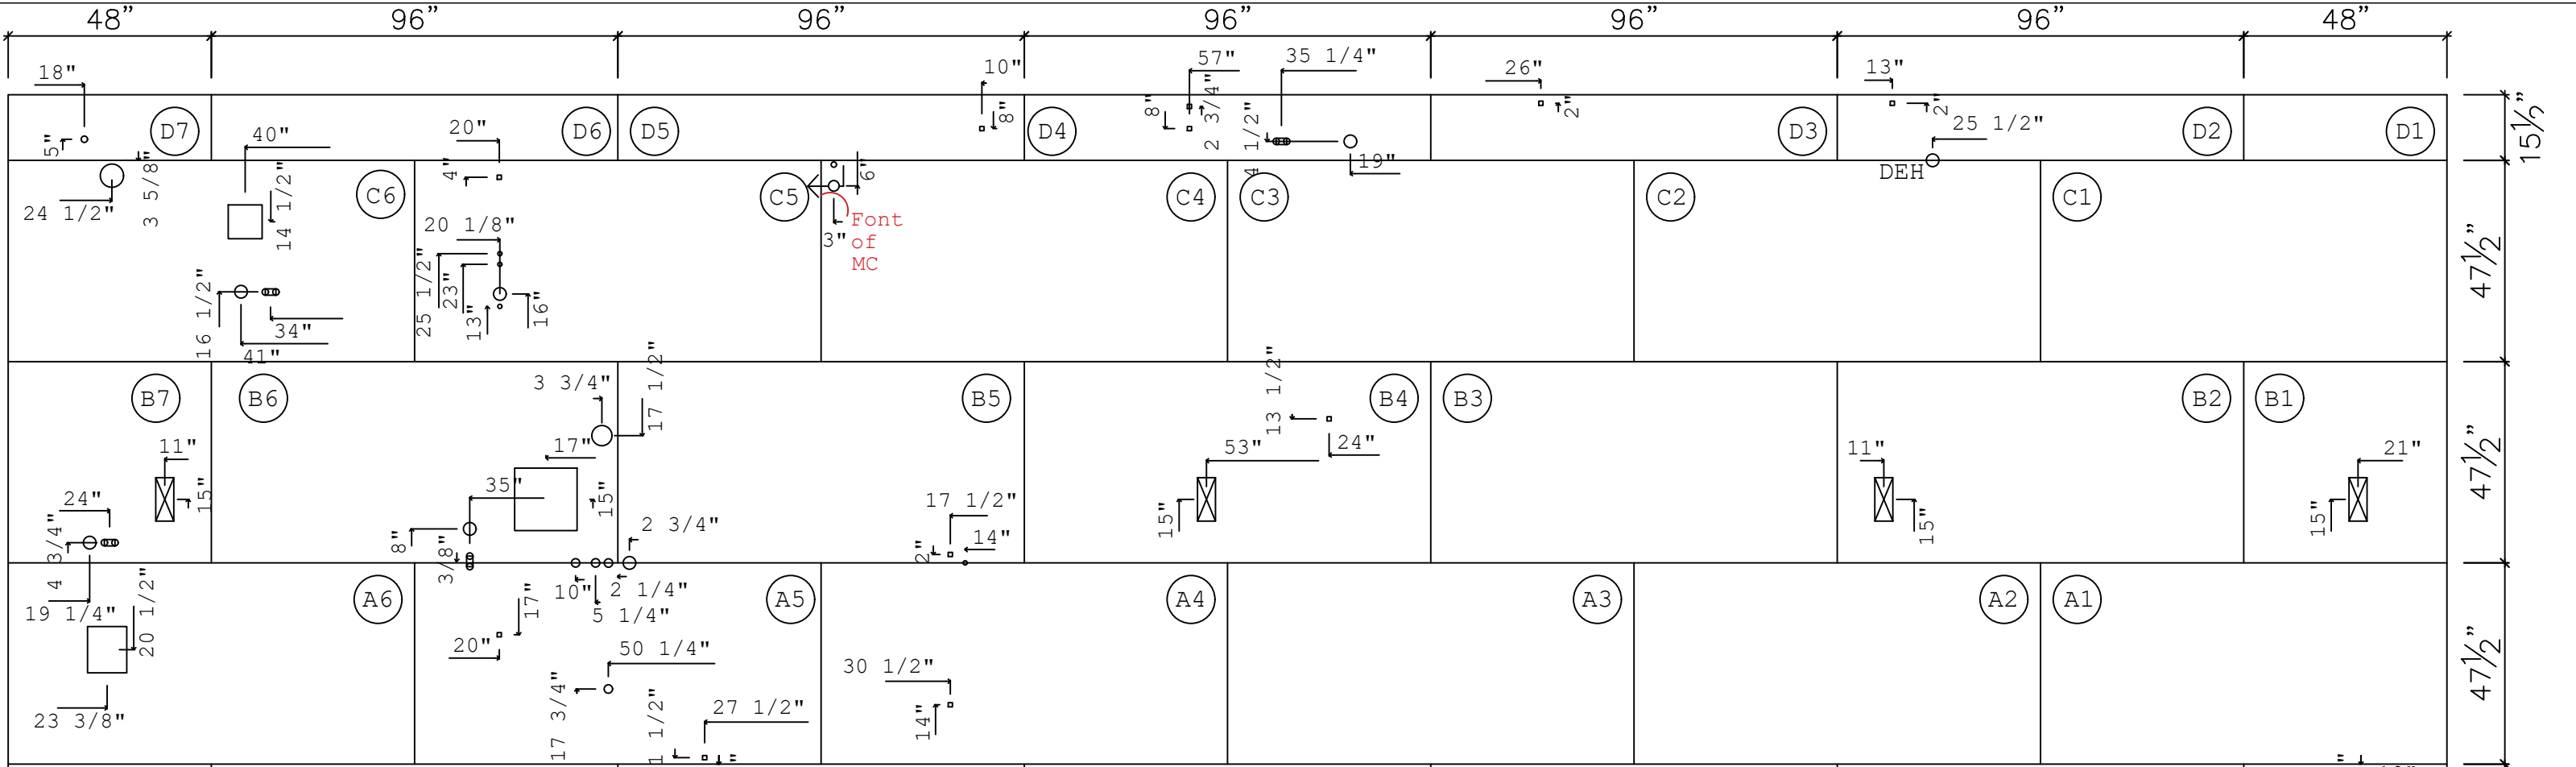

PRIMARY BATH 60" SHOWER ONLY HANDICAP SHOWER OPTION ONLY

PRIMARY BATH 72" SHOWER ONLY

SHEET: DECK	FLOOR DECKING B HALF PLAN 2X6	 Clayton - 934 1420 Mountain Rd, Andersonville, TN 37705 PH: 865.494.7800 FAX: 865.494.0243	HILBORN, WERNER, CARTER, AND ASSOCIATES, INC. 1627 SOUTH MYRTLE AVE. CLEARWATER, FL. 33756	DRAWING # 34M400-FP	MODEL: MOUNTAINEER 48 (28'x48')	STD PLAN *CONDITIONED*: 1,264 FT²
				MODEL # MTN28483A	SERIES: MOUNTAINEER	REV. BY:
				DATE: 4/29/2026	SCALE: N.T.S.	REV. DATE:
					PRODUCT DESIGNER: BRIAN K. RIFFEY	

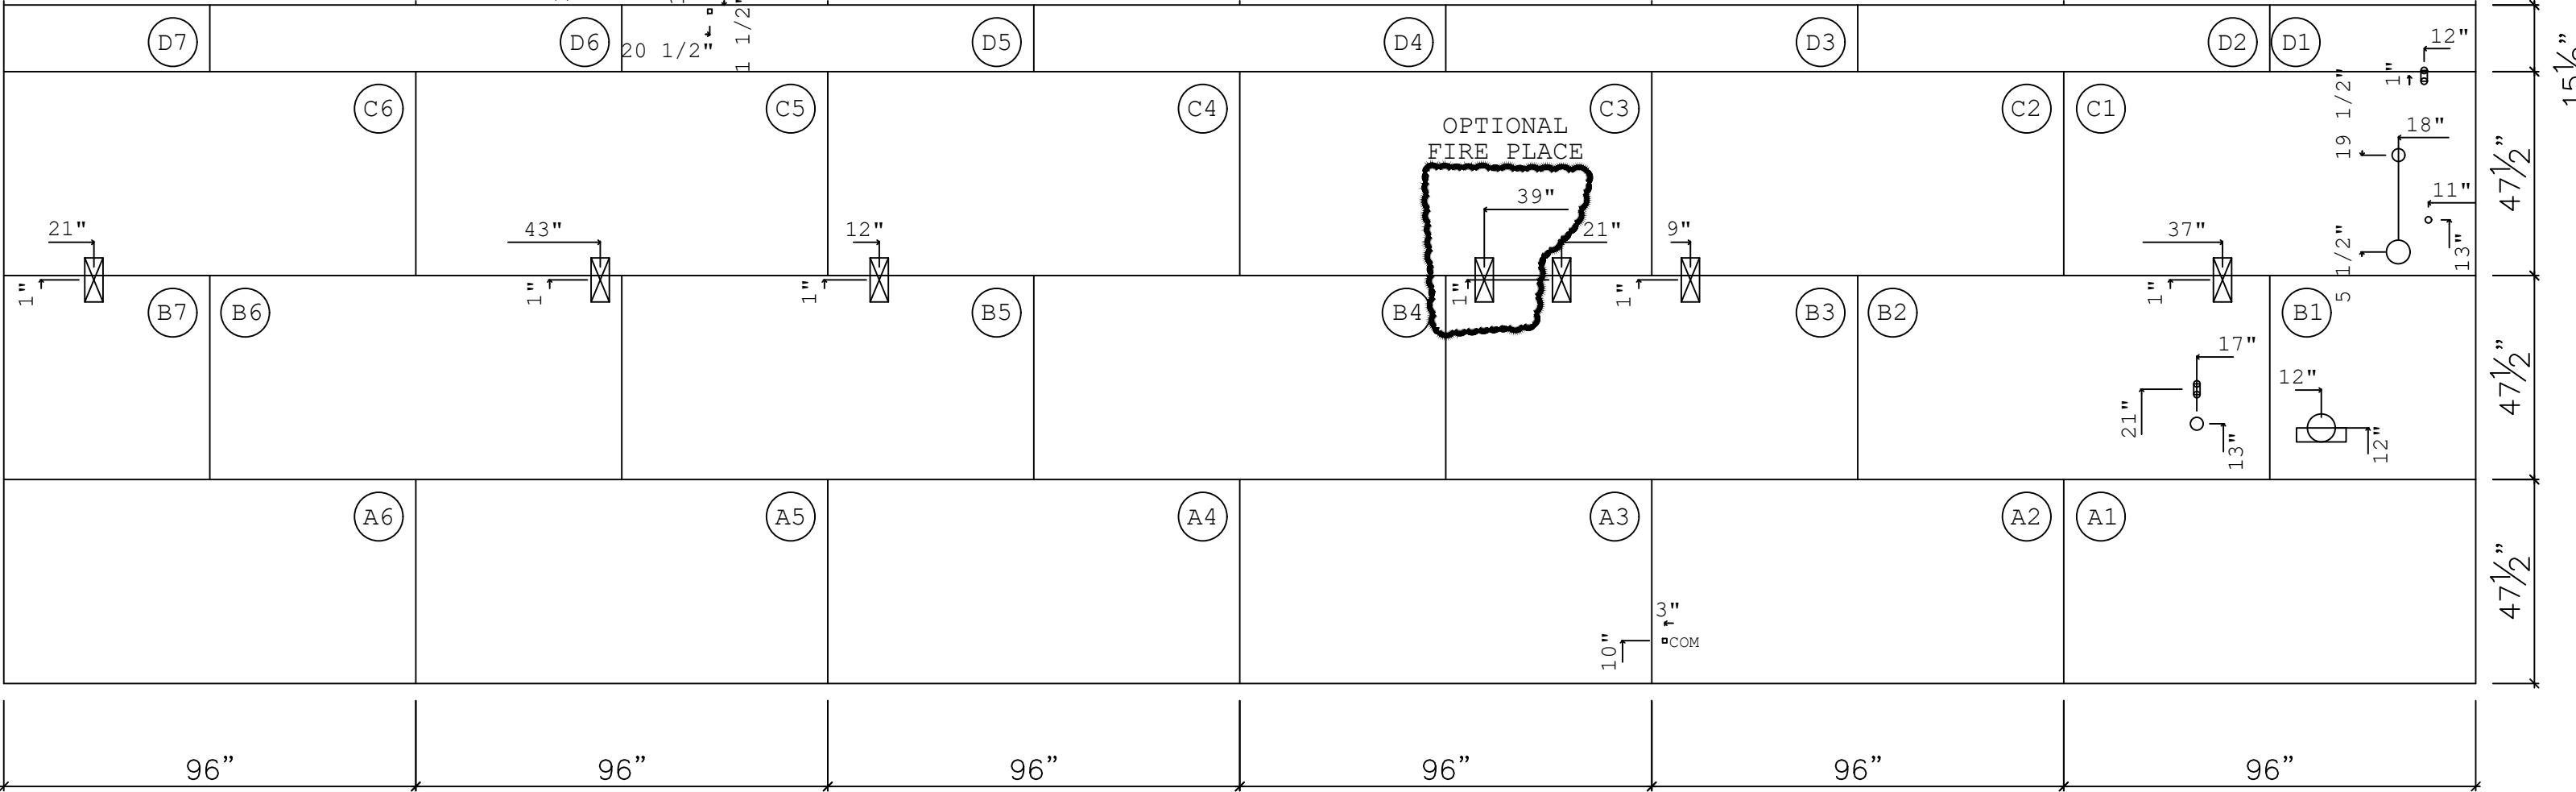

REV #	DATE	DESCRIPTION

SHEET:

DECK

FLOOR DECKING B
HALF PLAN 2X4


Clayton Clayton - 934
1420 Mountain Rd, Andersonville, TN 37705
PH: 865.494.7800 FAX: 865.494.0243

HILBORN, WERNER, CARTER,
AND ASSOCIATES, INC.
1627 SOUTH MYRTLE AVE.
CLEARWATER, FL. 33756


DRAWING #	34M400
MODEL #	MTN28483A
DATE:	4/29/2026
SCALE:	N.T.S.

MODEL:	MOUNTAINEER 48 (28'x48')
SERIES:	MOUNTAINEER
PRODUCT DESIGNER:	BRIAN K. RIFFEY

STD PLAN *CONDITIONED*:	1,264 FT²
REV. BY:	
REV. DATE:	





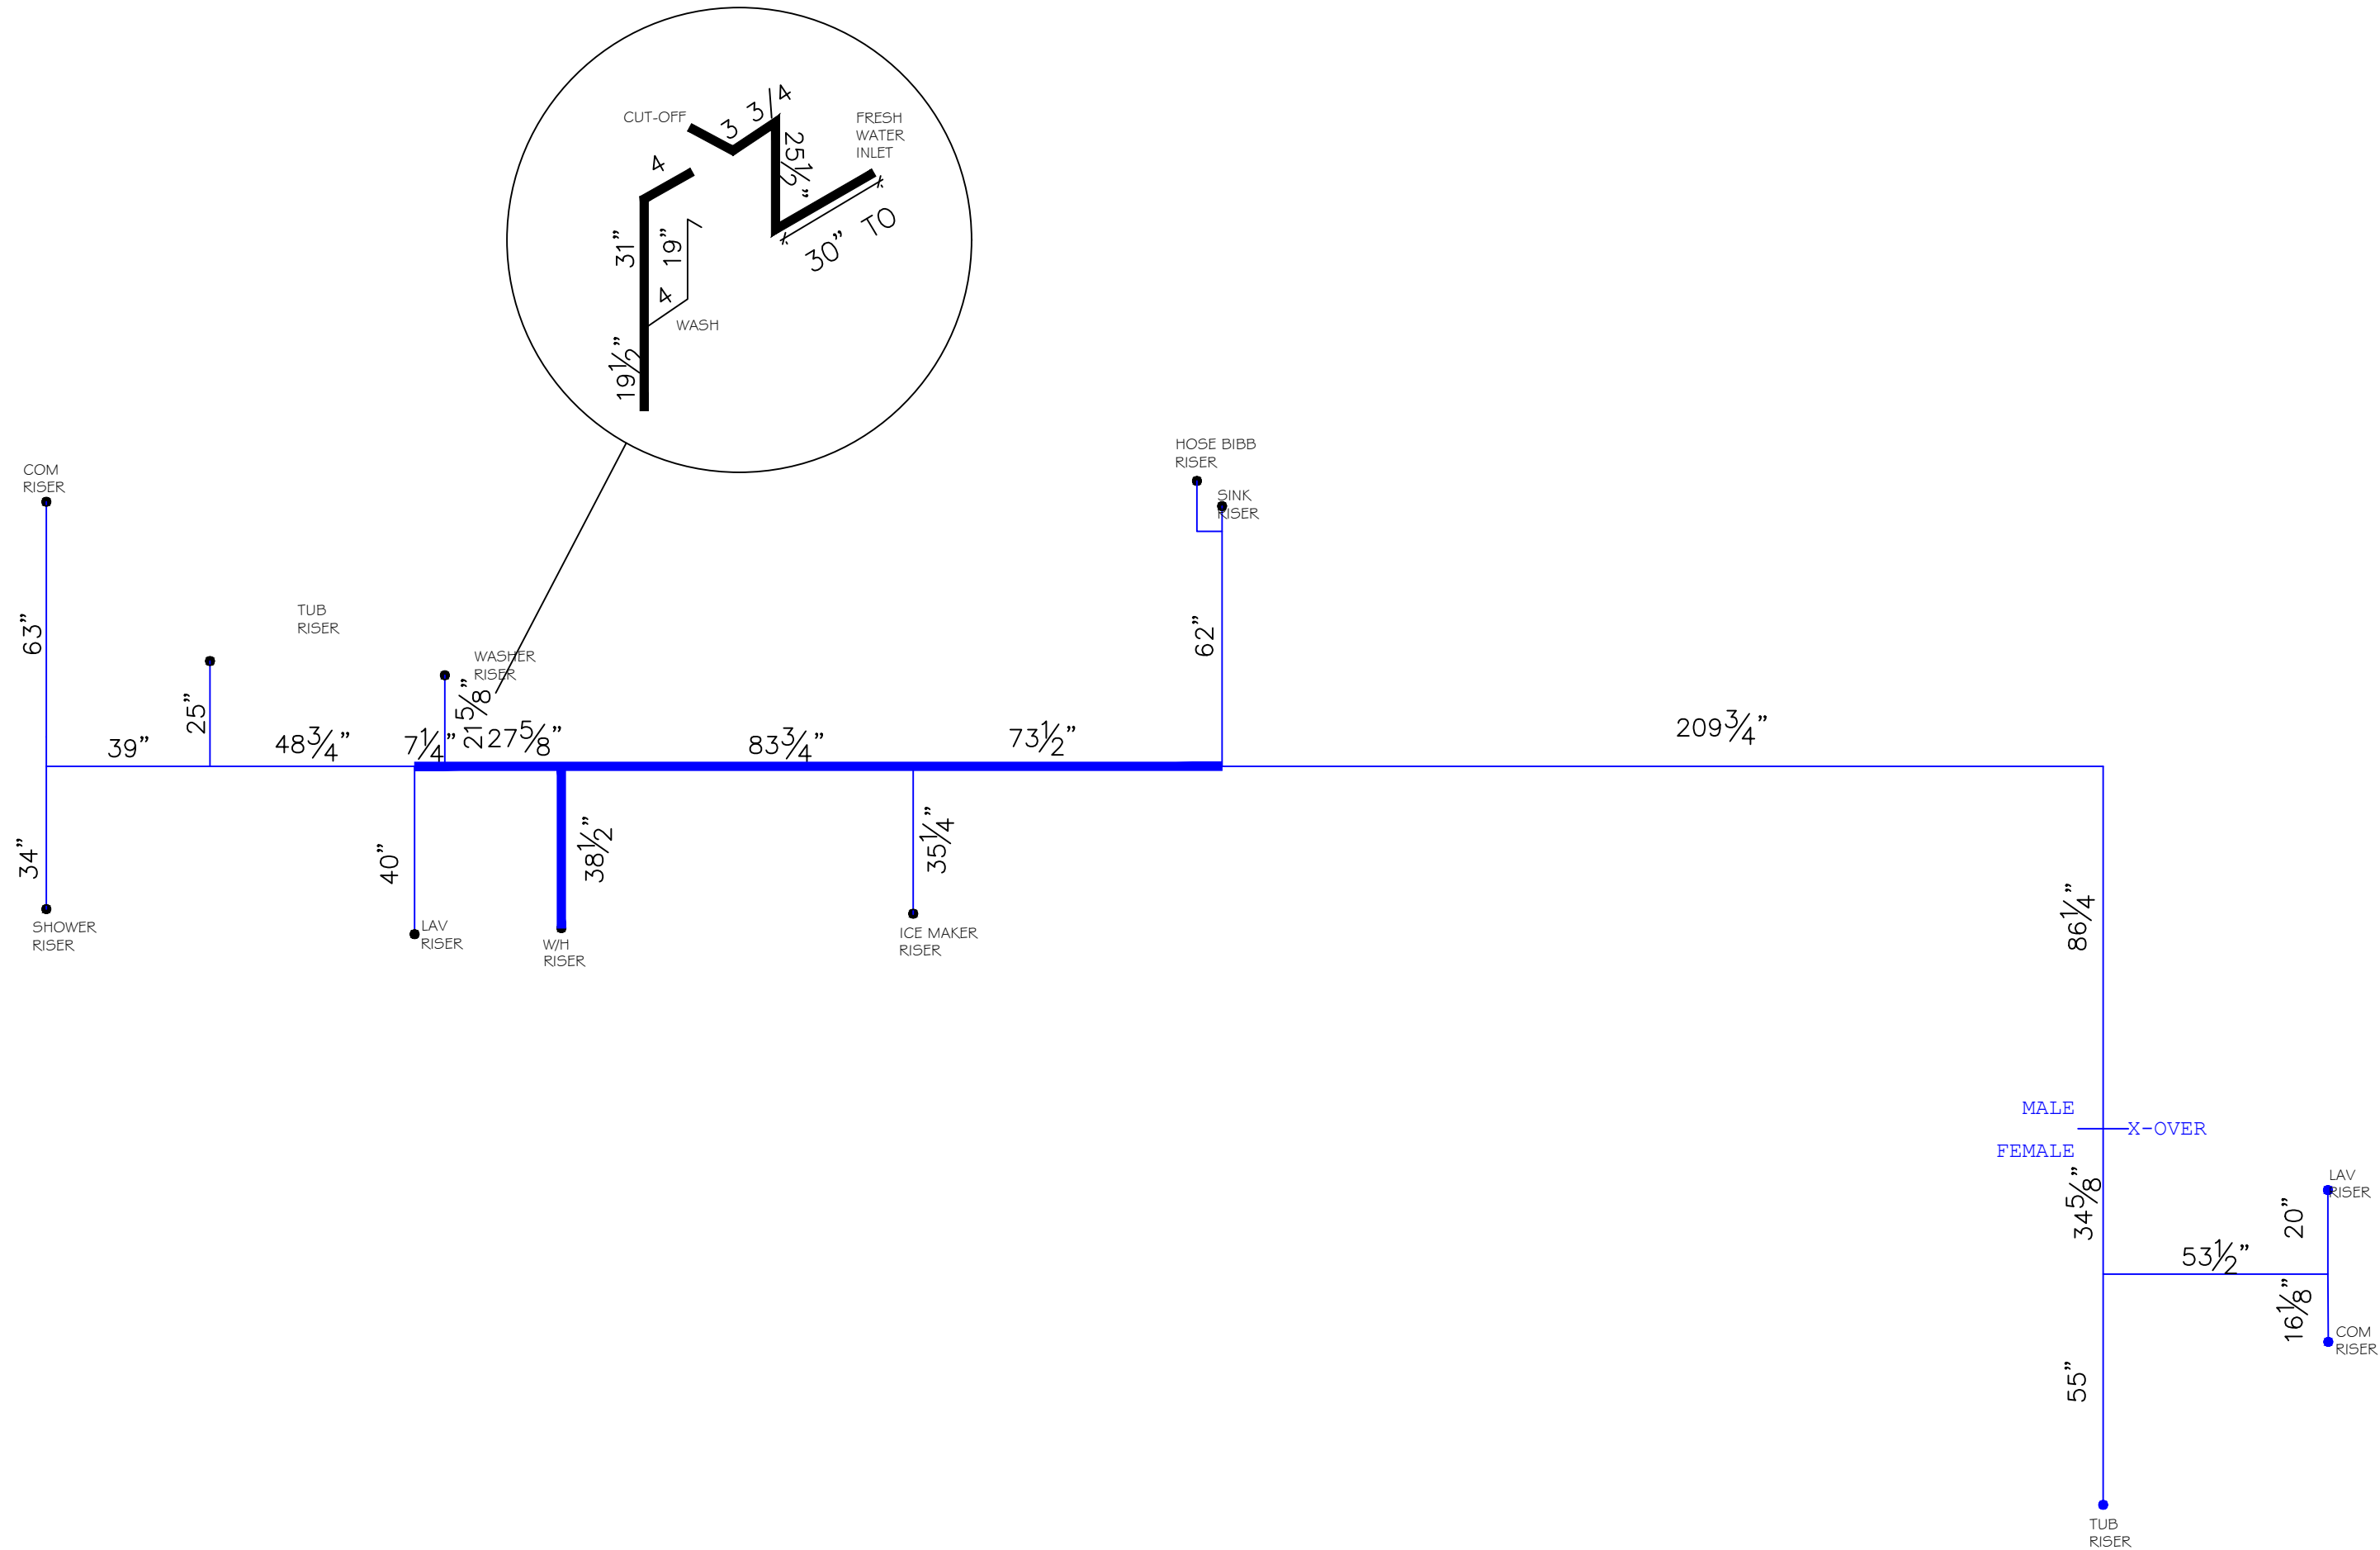




SHEET: CW	2D COLD WATER SUPPLY LINES	 Clayton - 934 1420 Mountain Rd, Andersonville, TN 37705 PH: 865.494.7800 FAX: 865.494.0243	HILBORN, WERNER, CARTER, AND ASSOCIATES, INC. 1627 SOUTH MYRTLE AVE. CLEARWATER, FL. 33756	DRAWING #: 34M400		MODEL: MOUNTAINEER 48 (28'x48')	STD PLAN *CONDITIONED*: 1,264 FT
				MODEL #: MTN28483A		SERIES: MOUNTAINEER	REV. BY:
				DATE: 4/29/2026	SCALE: N.T.S.	PRODUCT DESIGNER: BRIAN K. RIFFEY	REV. DATE:

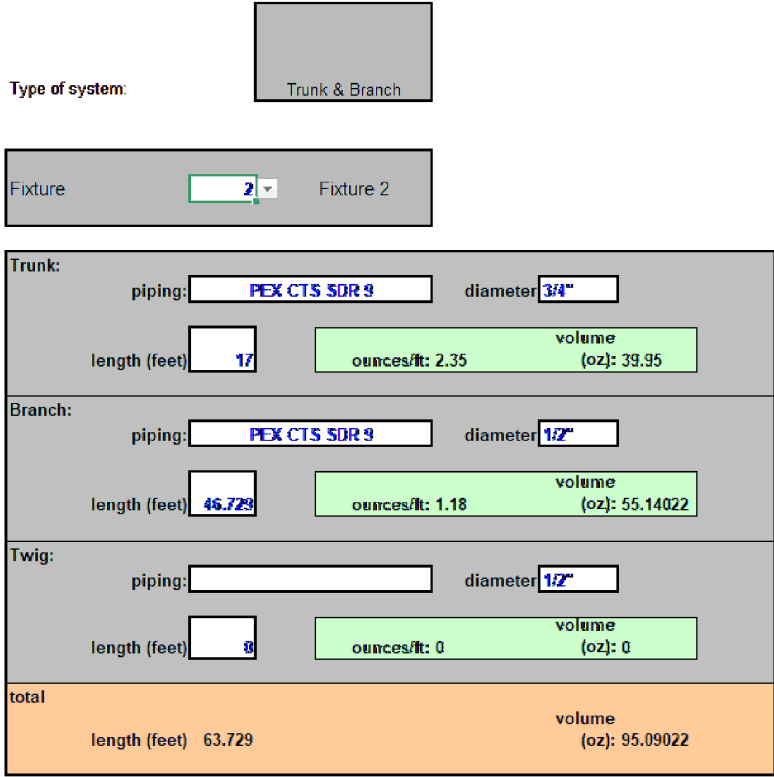


SHEET: HW	2D HOT WATER SUPPLY LINES	 Clayton - 934 1420 Mountain Rd, Andersonville, TN 37705 PH: 865.494.7800 FAX: 865.494.0243	HILBORN, WERNER, CARTER, AND ASSOCIATES, INC. 1627 SOUTH MYRTLE AVE. CLEARWATER, FL. 33756	DRAWING #: 34M400		MODEL: MOUNTAINEER 48 (28'x48')	STD PLAN "CONDITIONED": 1,264 FT²
				MODEL #: MTN28483A		SERIES: MOUNTAINEER	REV. BY:
				DATE: 4/29/2026	SCALE: N.T.S.	PRODUCT DESIGNER: BRIAN K. RIFFEY	REV. DATE:


REV #	DATE	DESCRIPTION
-	-	-

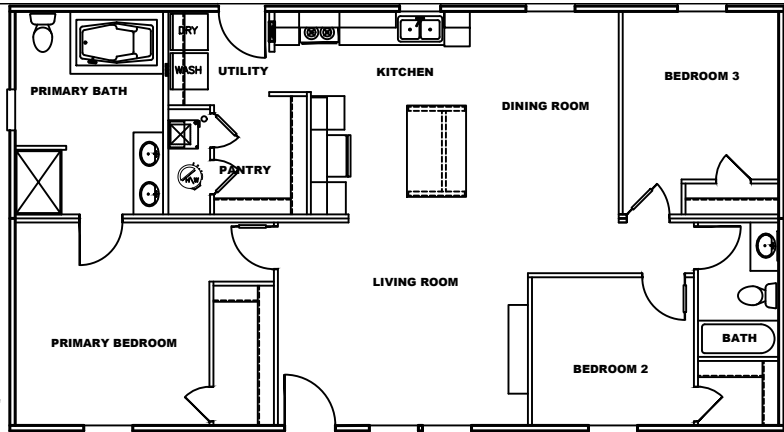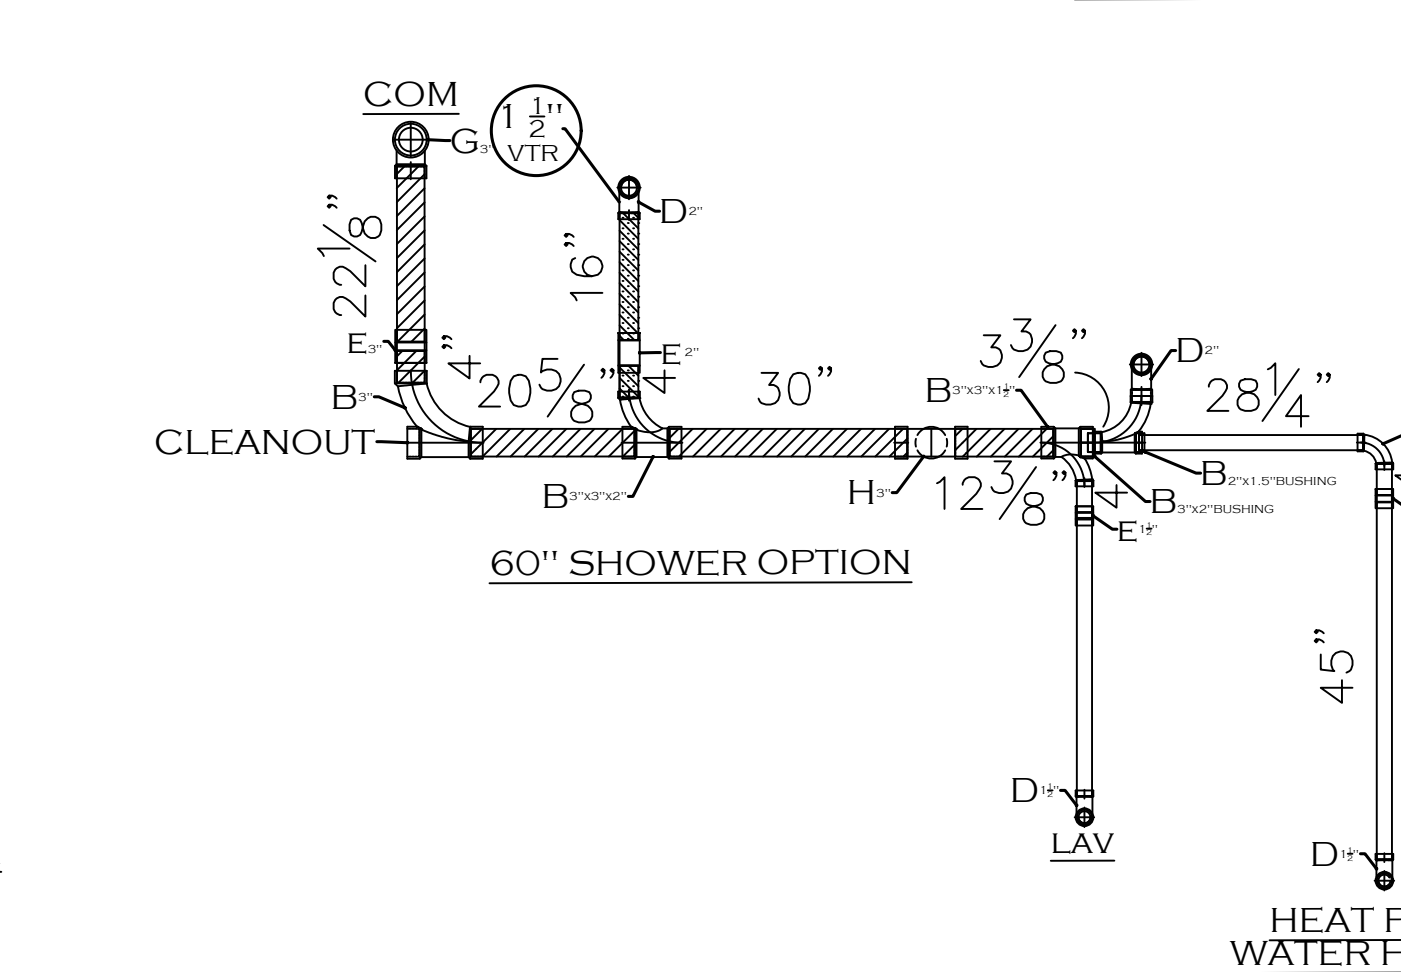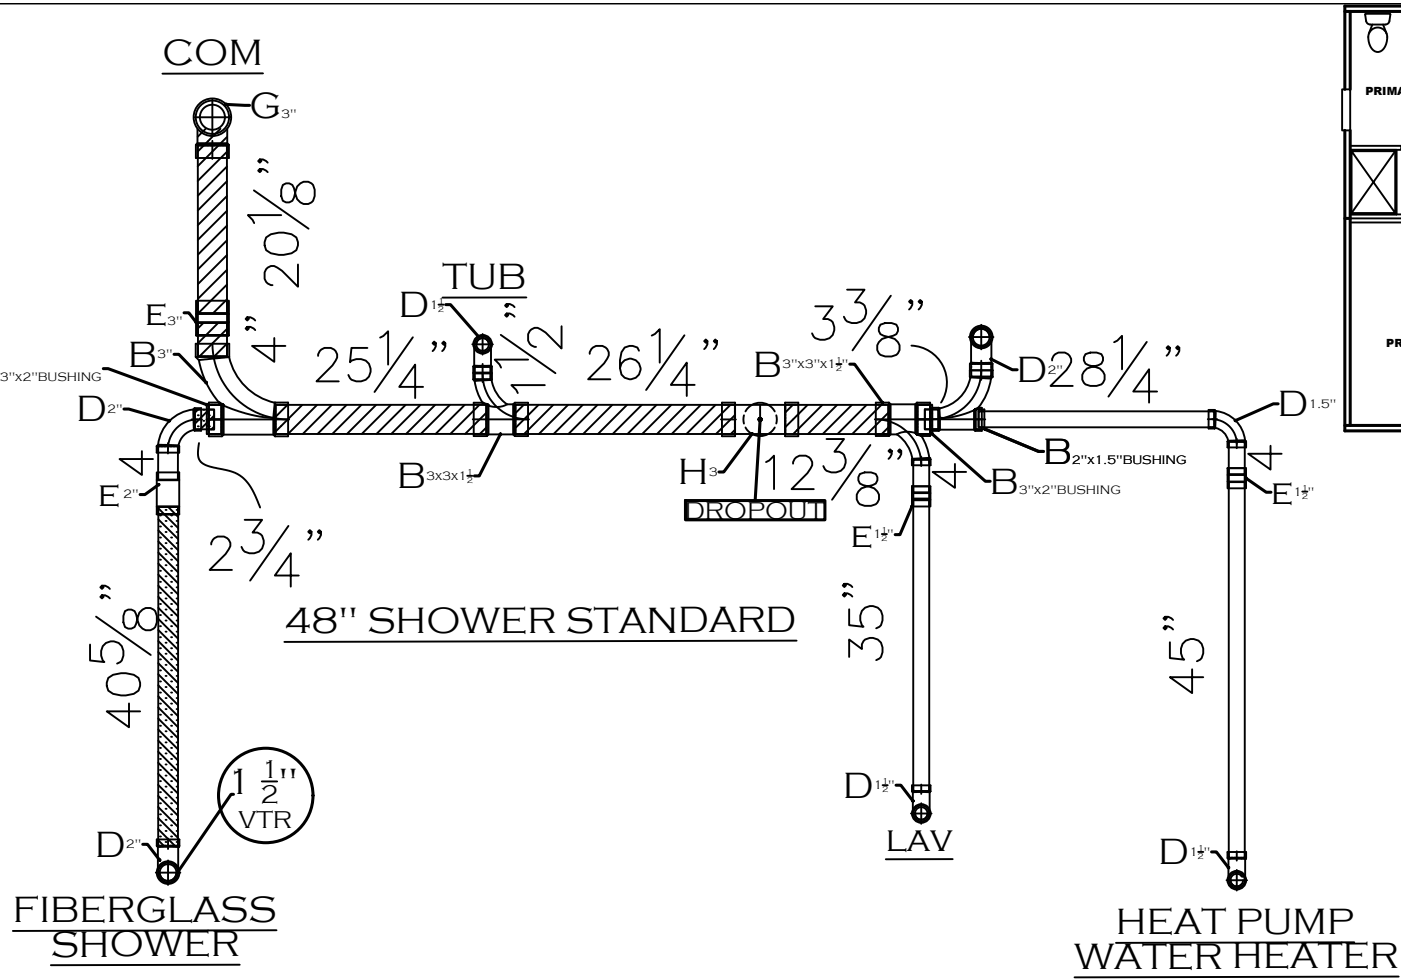
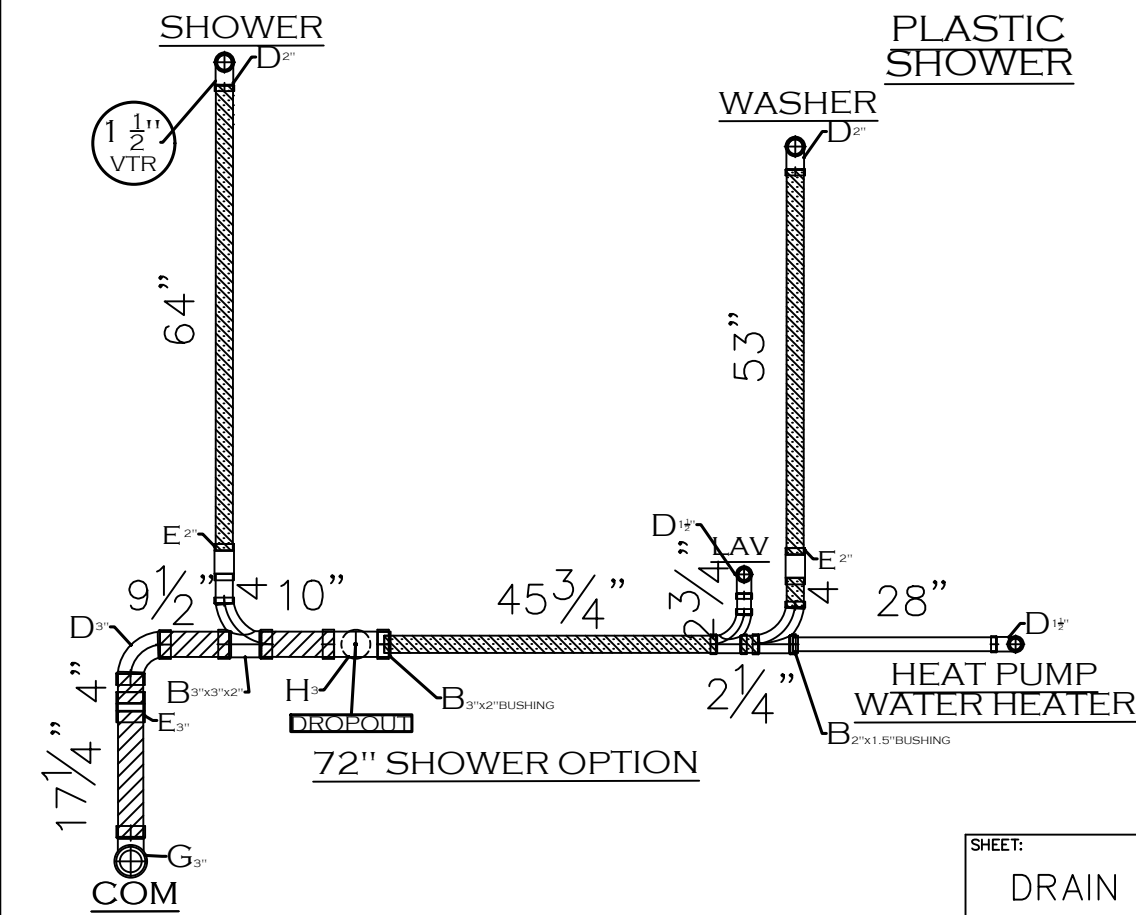
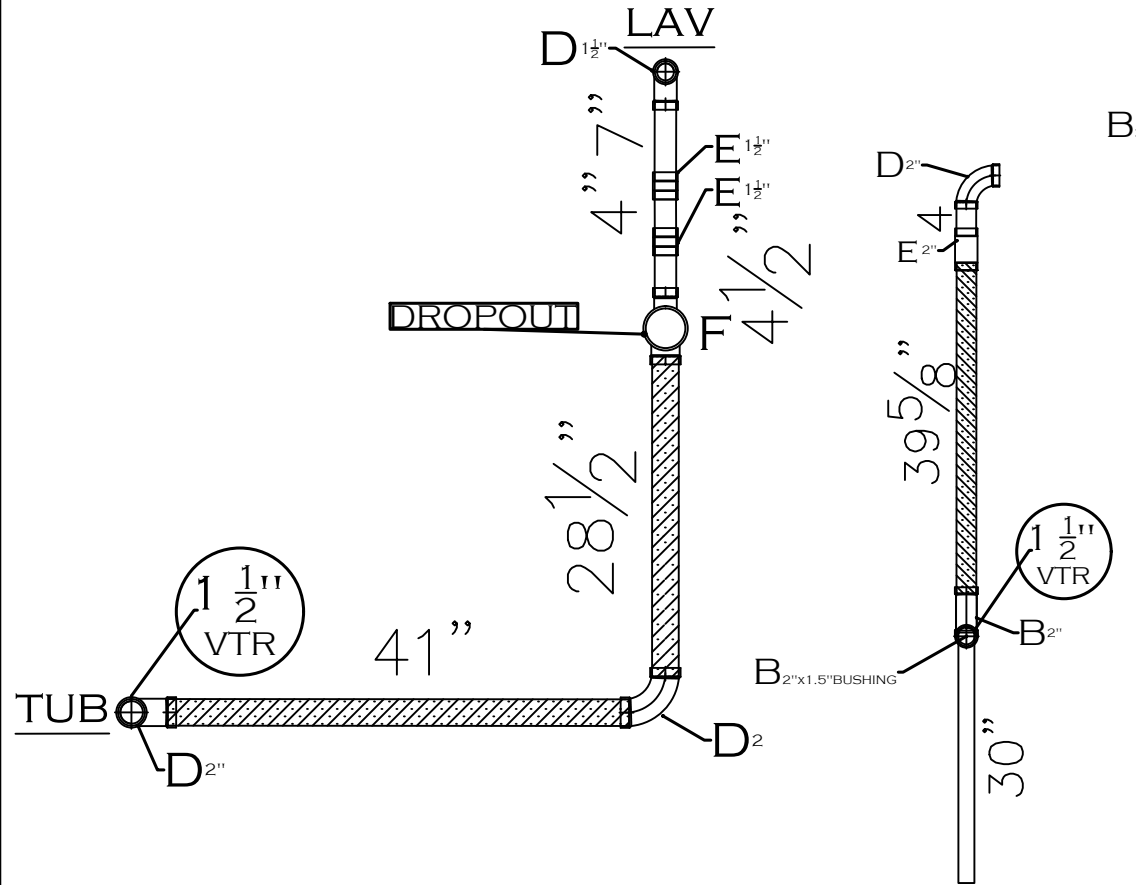


  
D.W.V. LINE SIZE CHART	
	= 3"
	= 2"
	= 1 1/2"

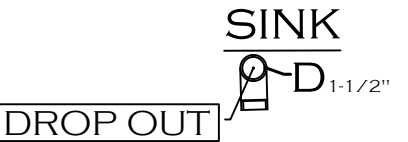


SHEET: DRAIN	2D DRAIN LINES 2x6	 Clayton - 934 1420 Mountain Rd, Andersonville, TN 37705 PH: 865.494.7800 FAX: 865.494.0243	HILBORN, WERNER, CARTER, AND ASSOCIATES, INC. 1627 SOUTH MYRTLE AVE. CLEARWATER, FL. 33756	DRAWING # 34M400	MODEL: MOUNTAINEER 48 (28'x48')	STD PLAN *CONDITIONED*: 1,264 FT²
				MODEL # MTN28483A	SERIES: MOUNTAINEER	REV. BY:
				DATE: 4/29/2026	SCALE: N.T.S.	PRODUCT DESIGNER: BRIAN K. RIFFEY
						REV. DATE:

 

   


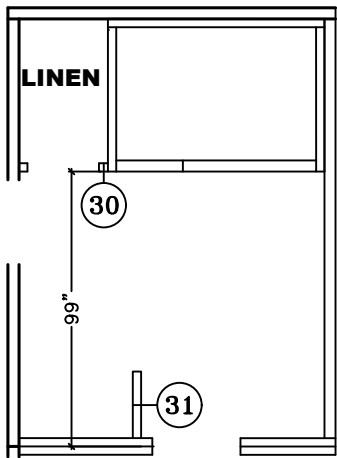


PRIMARY BATH 72" SHOWER ONLY

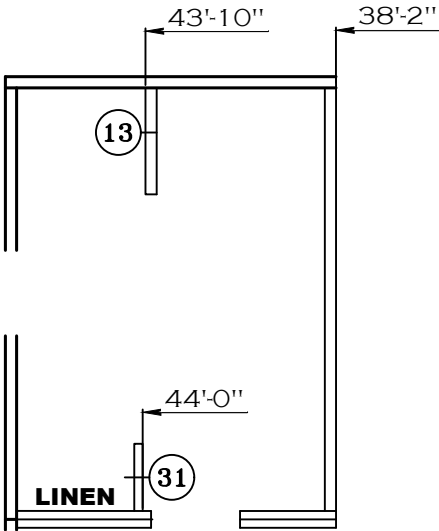



PRIMARY BATH 60" SHOWER ONLY

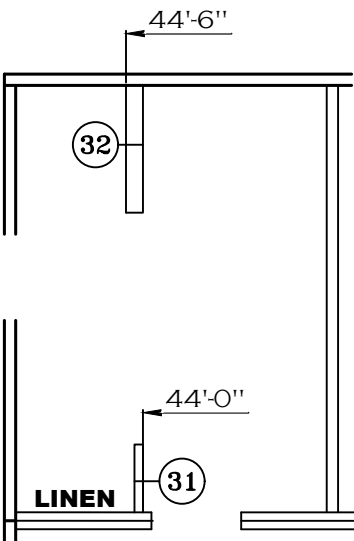



OPT. PRIMARY BATH 65" HANDICAP SHOWER

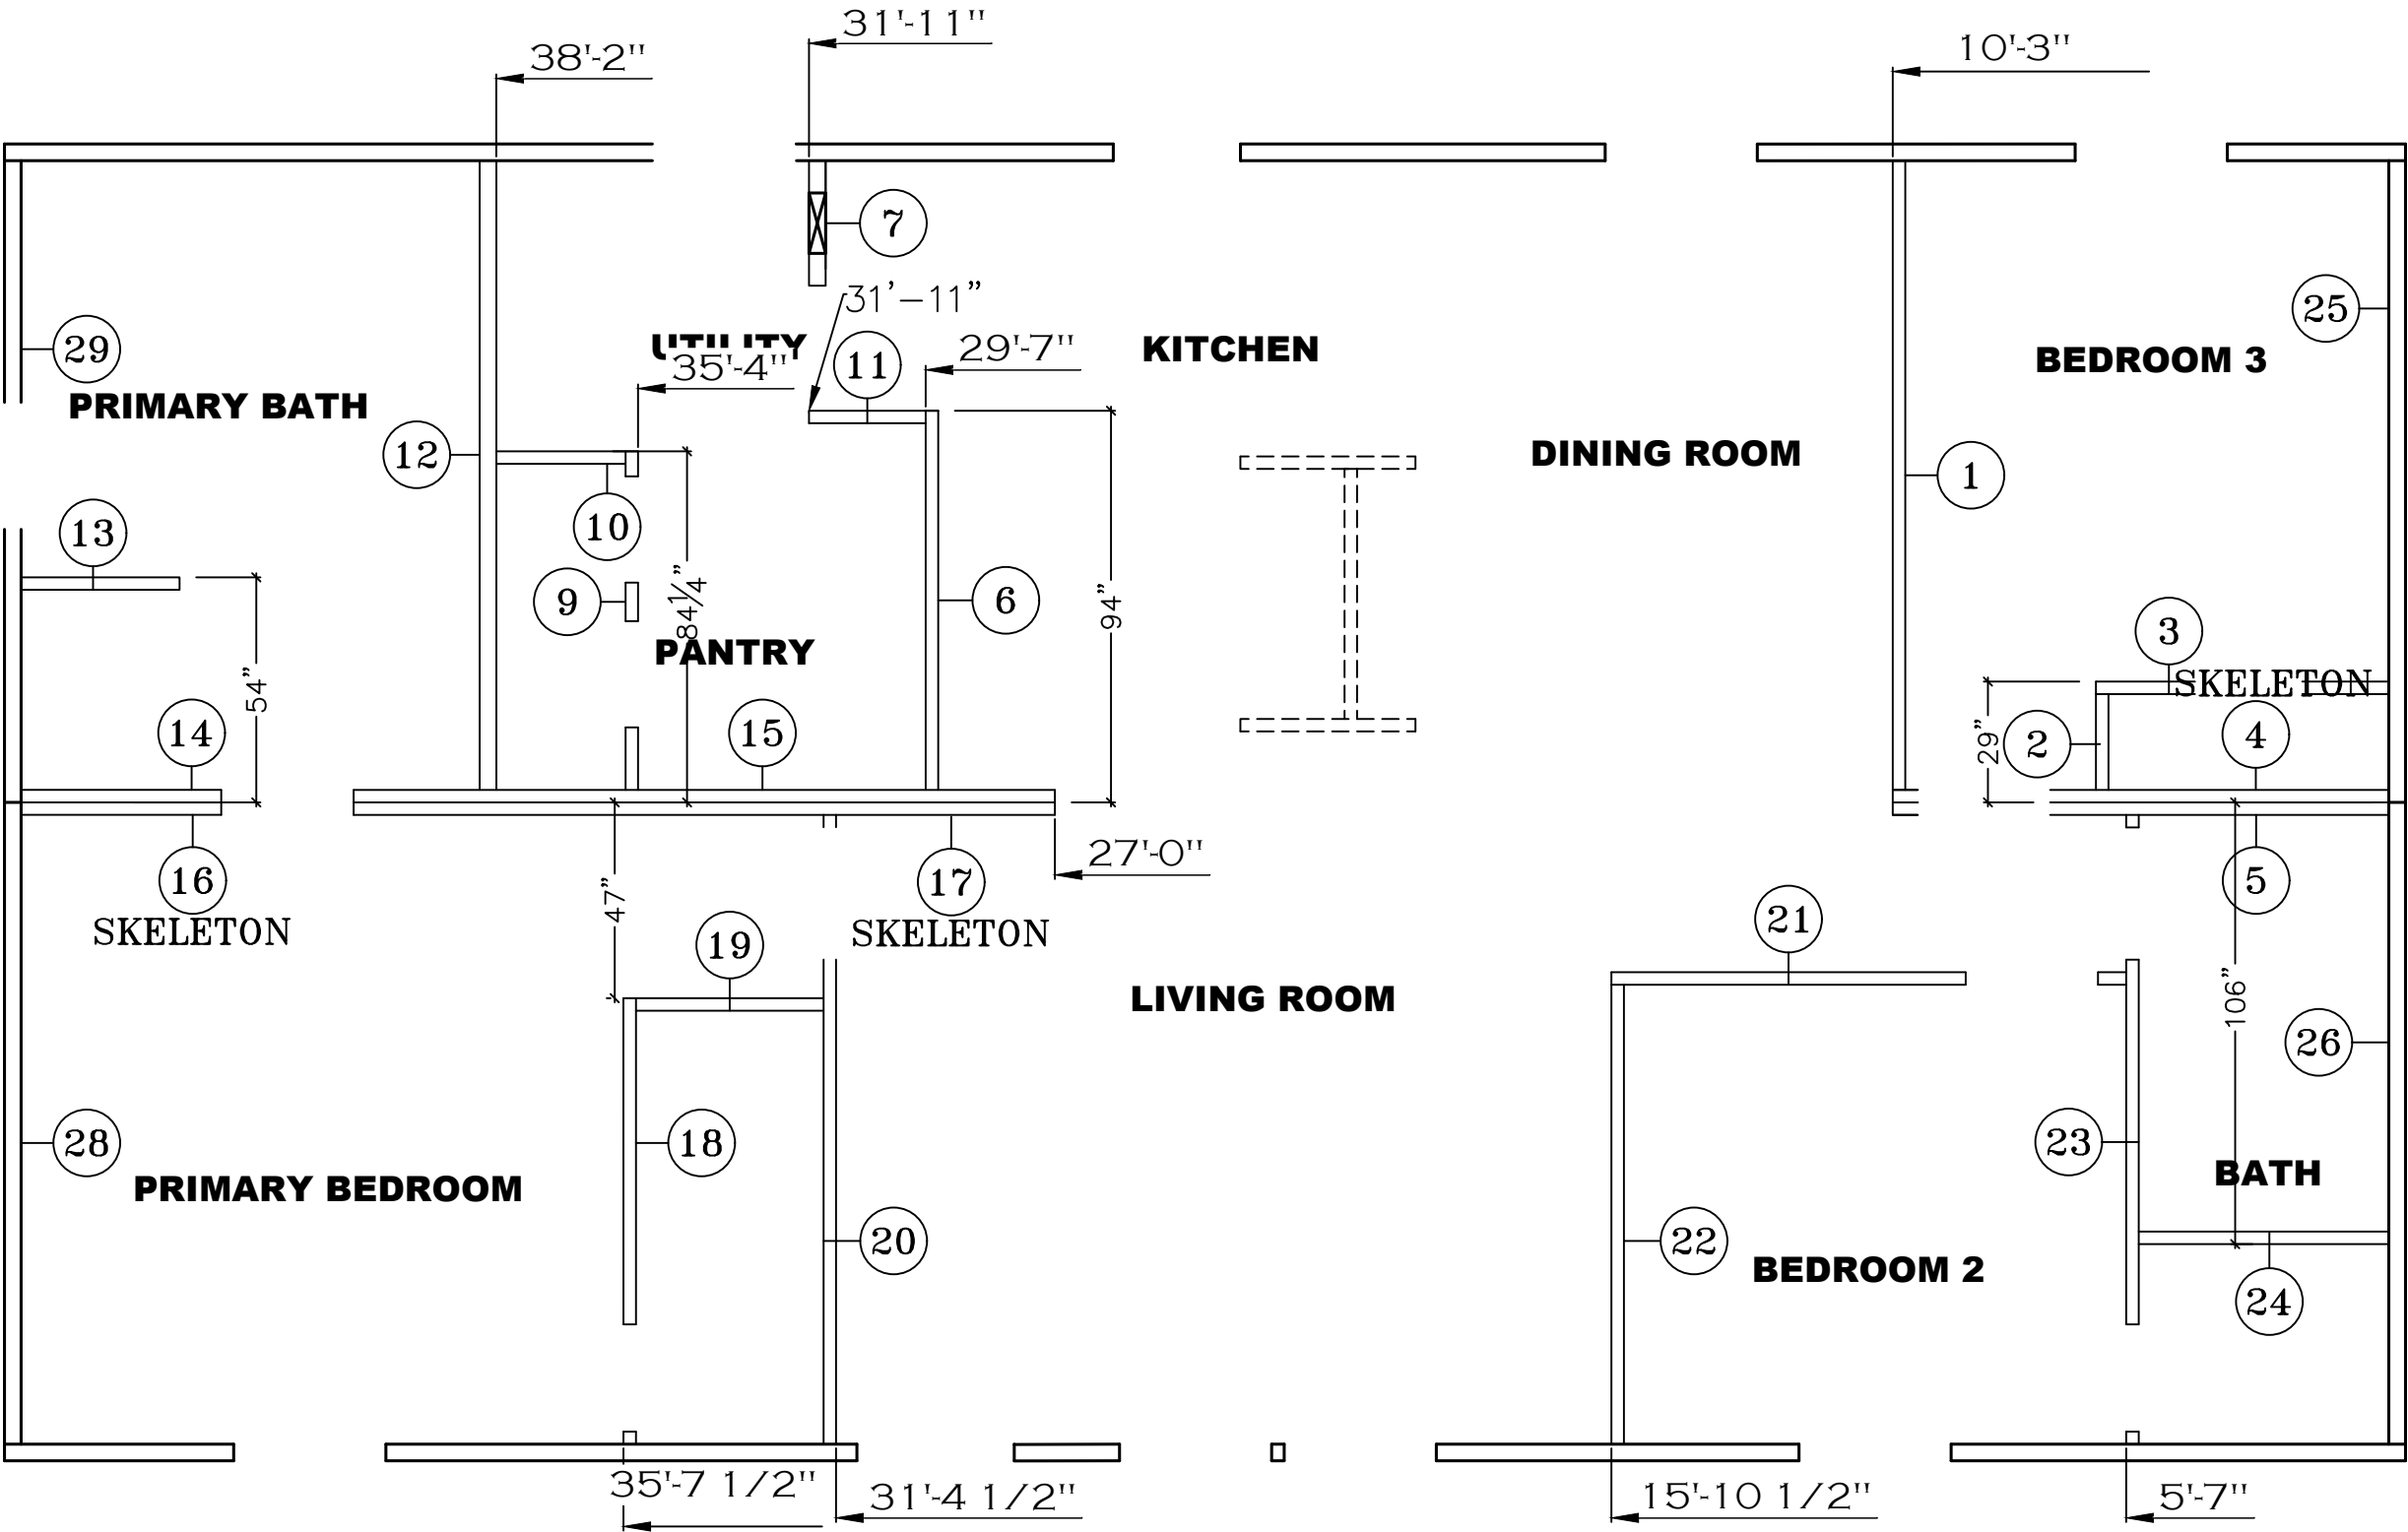



SHEET:	BASE	WALL SET PLAN	Clayton Clayton - 934 1420 Mountain Rd, Andersonville, TN 37705 PH: 865.494.7800 FAX: 865.494.0243	HILBORN, WERNER, CARTER, AND ASSOCIATES, INC. 1627 SOUTH MYRTLE AVE. CLEARWATER, FL. 33756	DRAWING # 34M400		MODEL: MOUNTAINEER 48 (28'x48')	STD PLAN *CONDITIONED*: 1,264 FT²
					MODEL # MTN28483A		SERIES: MOUNTAINEER	
					DATE: 4/29/2026	SCALE: N.T.S.	PRODUCT DESIGNER: BRIAN K. RIFFEY	
							REV. DATE:	

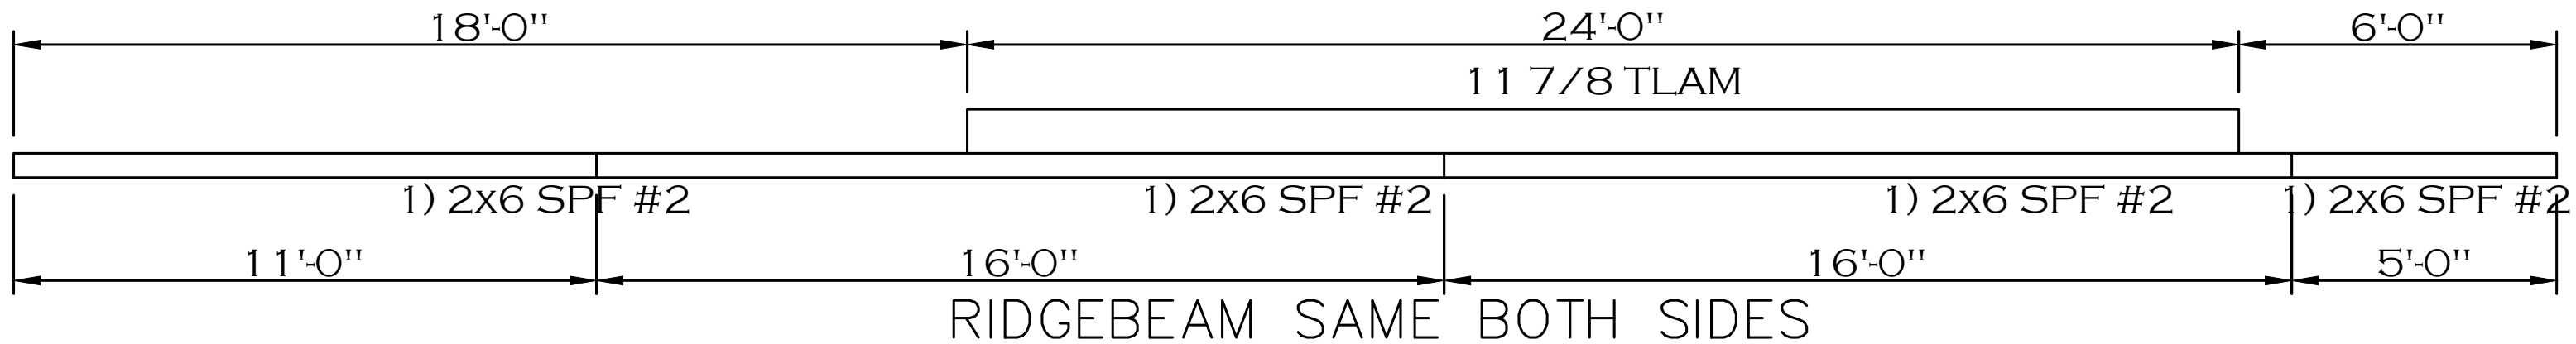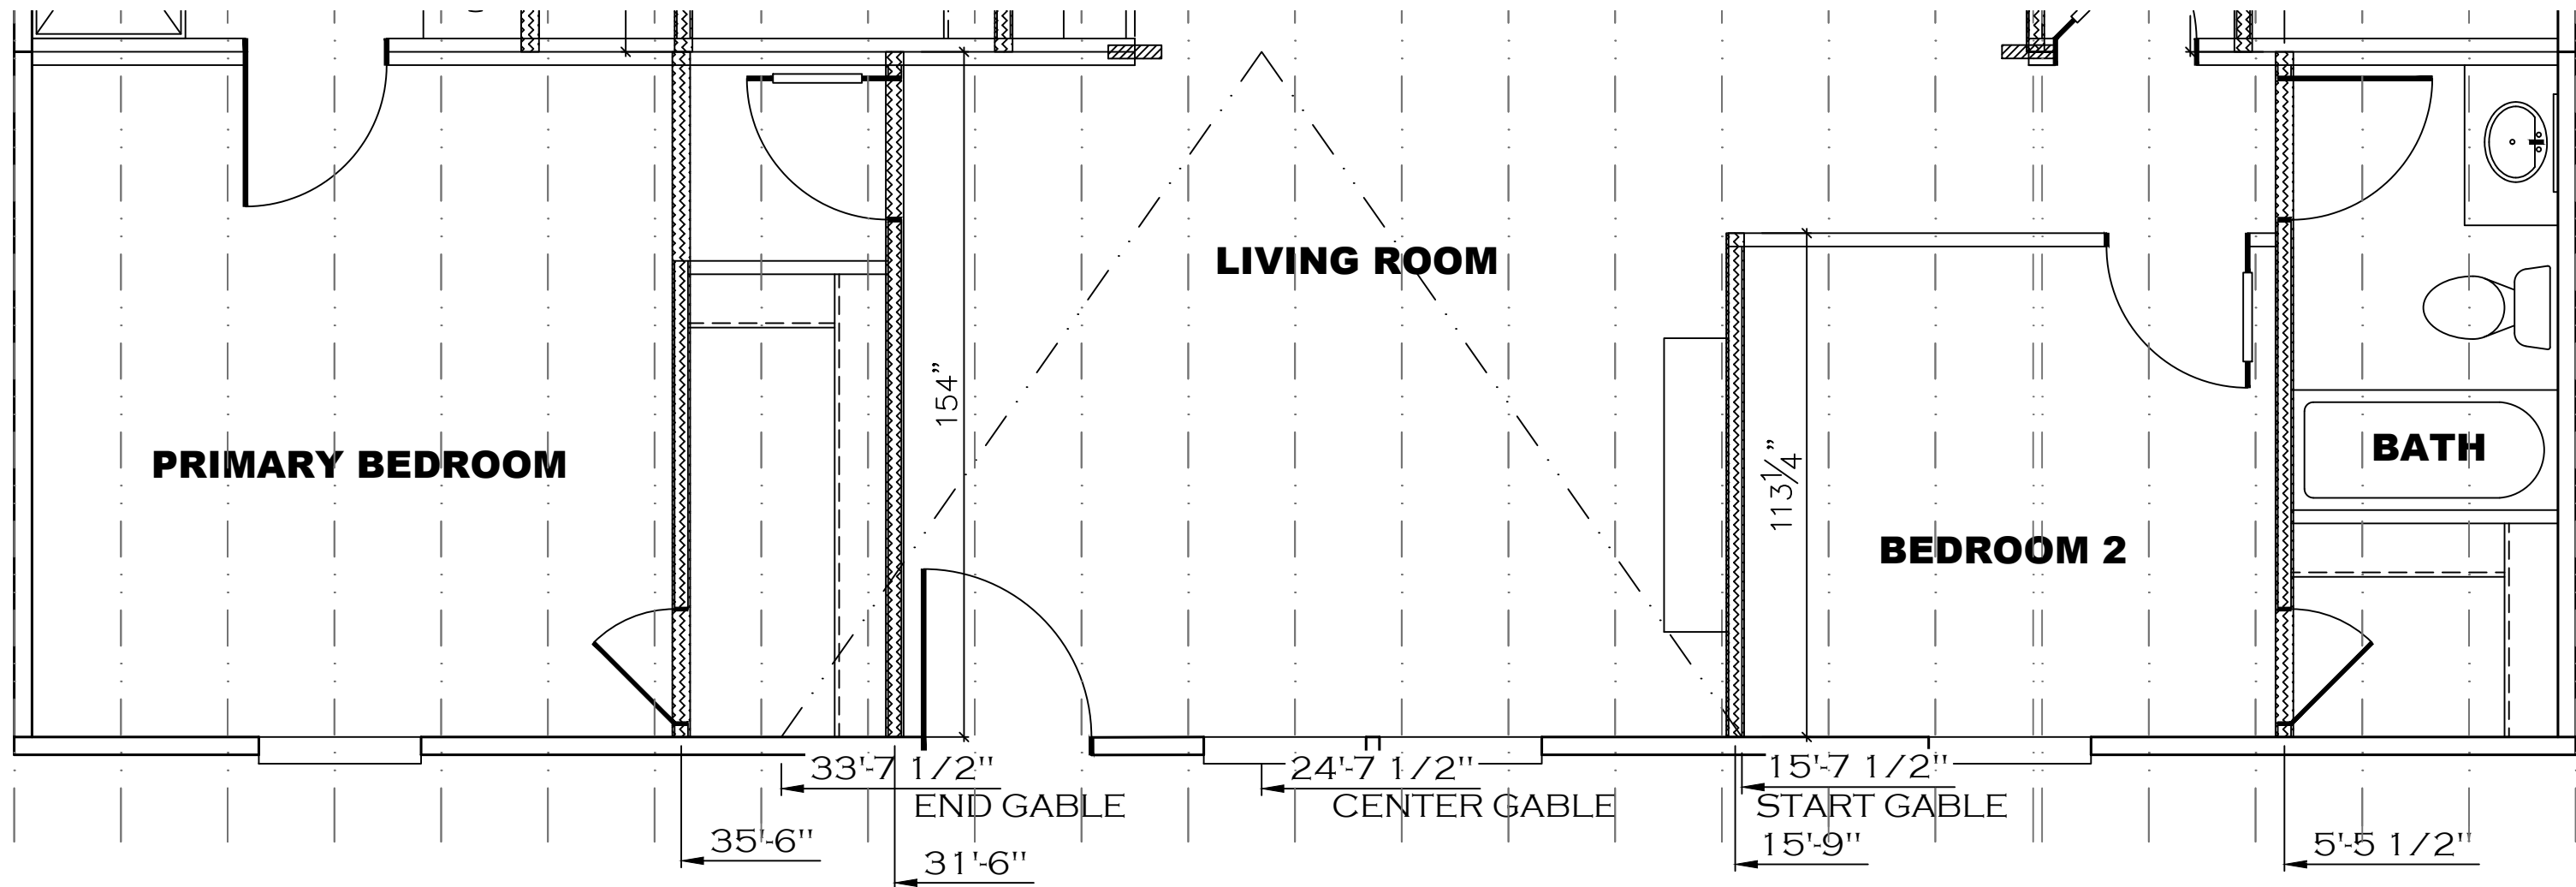




SHEET: CJIG	RIDGEBEAM – RAFTER PLAN B HALF	 Clayton - 934 1420 Mountain Rd, Andersonville, TN 37705 PH: 865.494.7800 FAX: 865.494.0243	HILBORN, WERNER, CARTER, AND ASSOCIATES, INC. 1627 SOUTH MYRTLE AVE. CLEARWATER, FL. 33756		DRAWING #: 34M400		MODEL: MOUNTAINEER 48 (28'x48')		STD PLAN "CONDITIONED": 1,264 FT²	
					MODEL #: MTN28483A		SERIES: MOUNTAINEER		REV. BY:	
					DATE: 4/29/2026		SCALE: N.T.S.		PRODUCT DESIGNER: BRIAN K. RIFFEY	

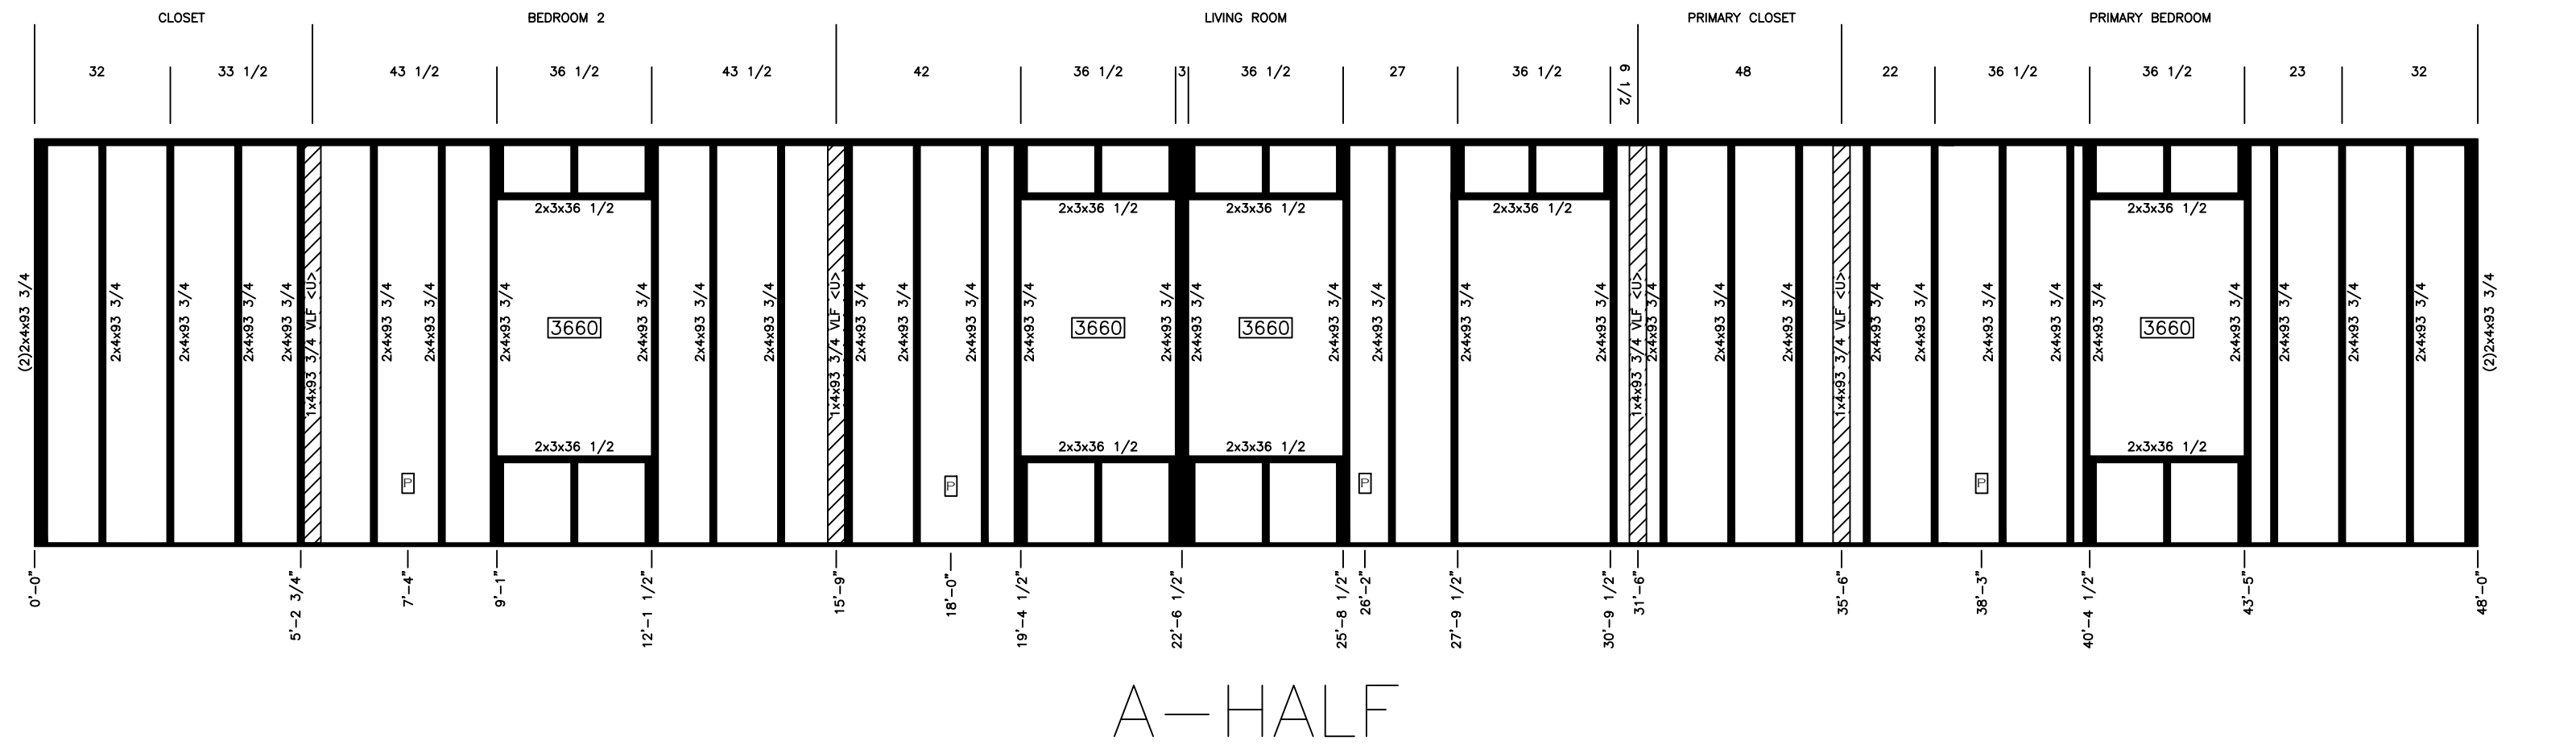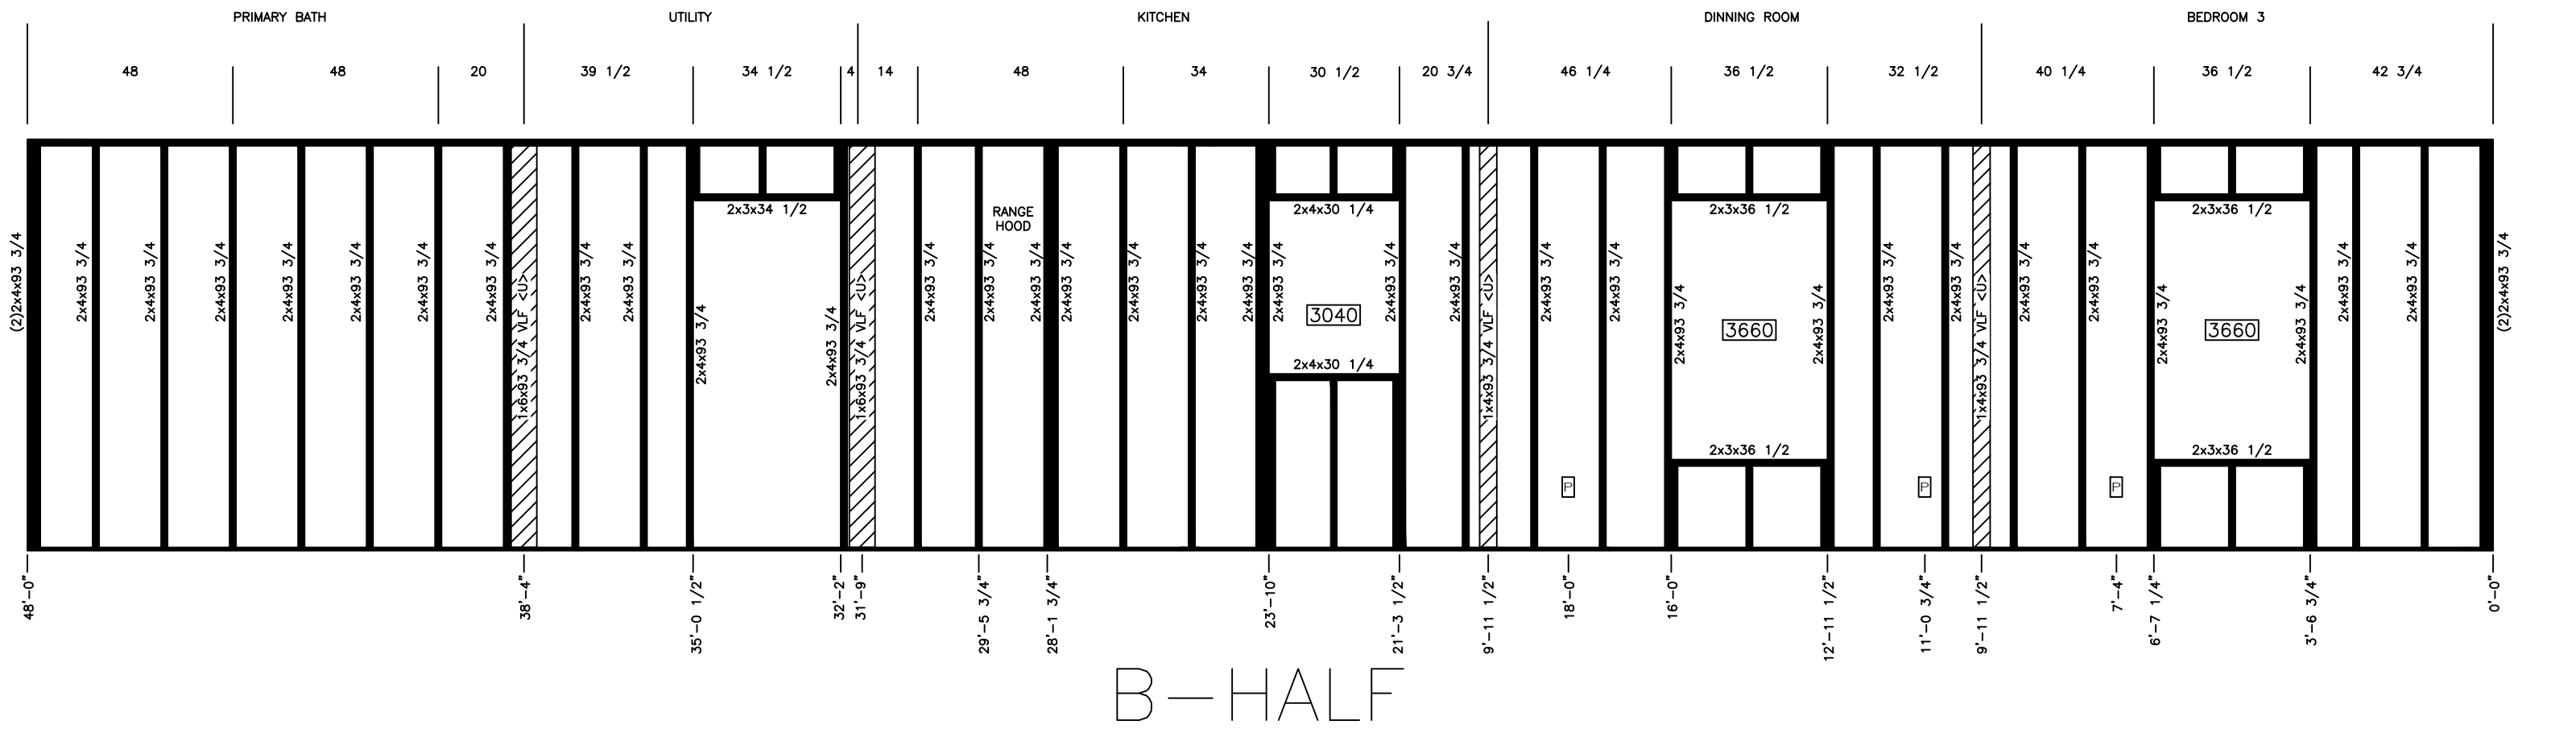

SHEET:	BASE	WALL SET PLAN	Clayton Clayton - 934 1420 Mountain Rd, Andersonville, TN 37705 PH: 865.494.7800 FAX: 865.494.0243	HILBORN, WERNER, CARTER, AND ASSOCIATES, INC. 1627 SOUTH MYRTLE AVE. CLEARWATER, FL. 33756	DRAWING #: 34M400		MODEL: MOUNTAINEER 48 (28'x48')	STD PLAN "CONDITIONED": 1,264 F
					MODEL #: MTN28483A		SERIES: MOUNTAINEER	REV. BY:
					DATE: 4/29/2026	SCALE: N.T.S.	PRODUCT DESIGNER: BRIAN K. RIFFEY	REV. DATE:

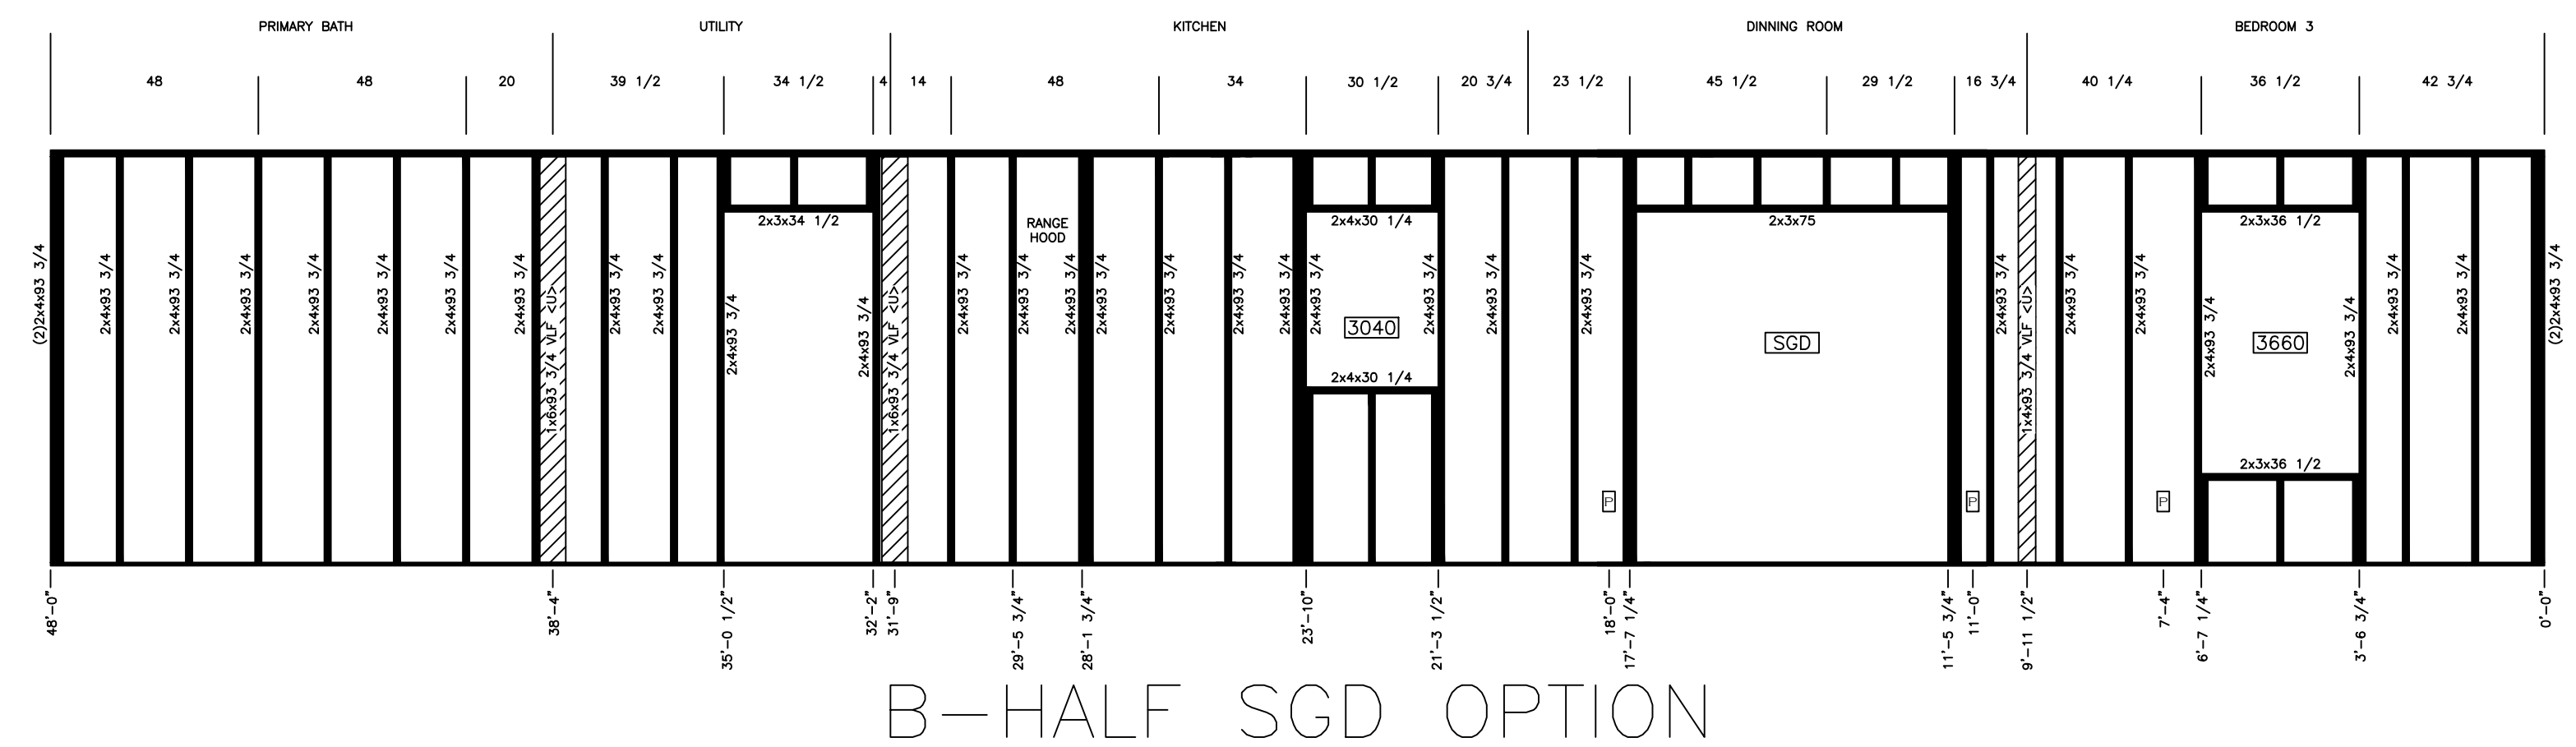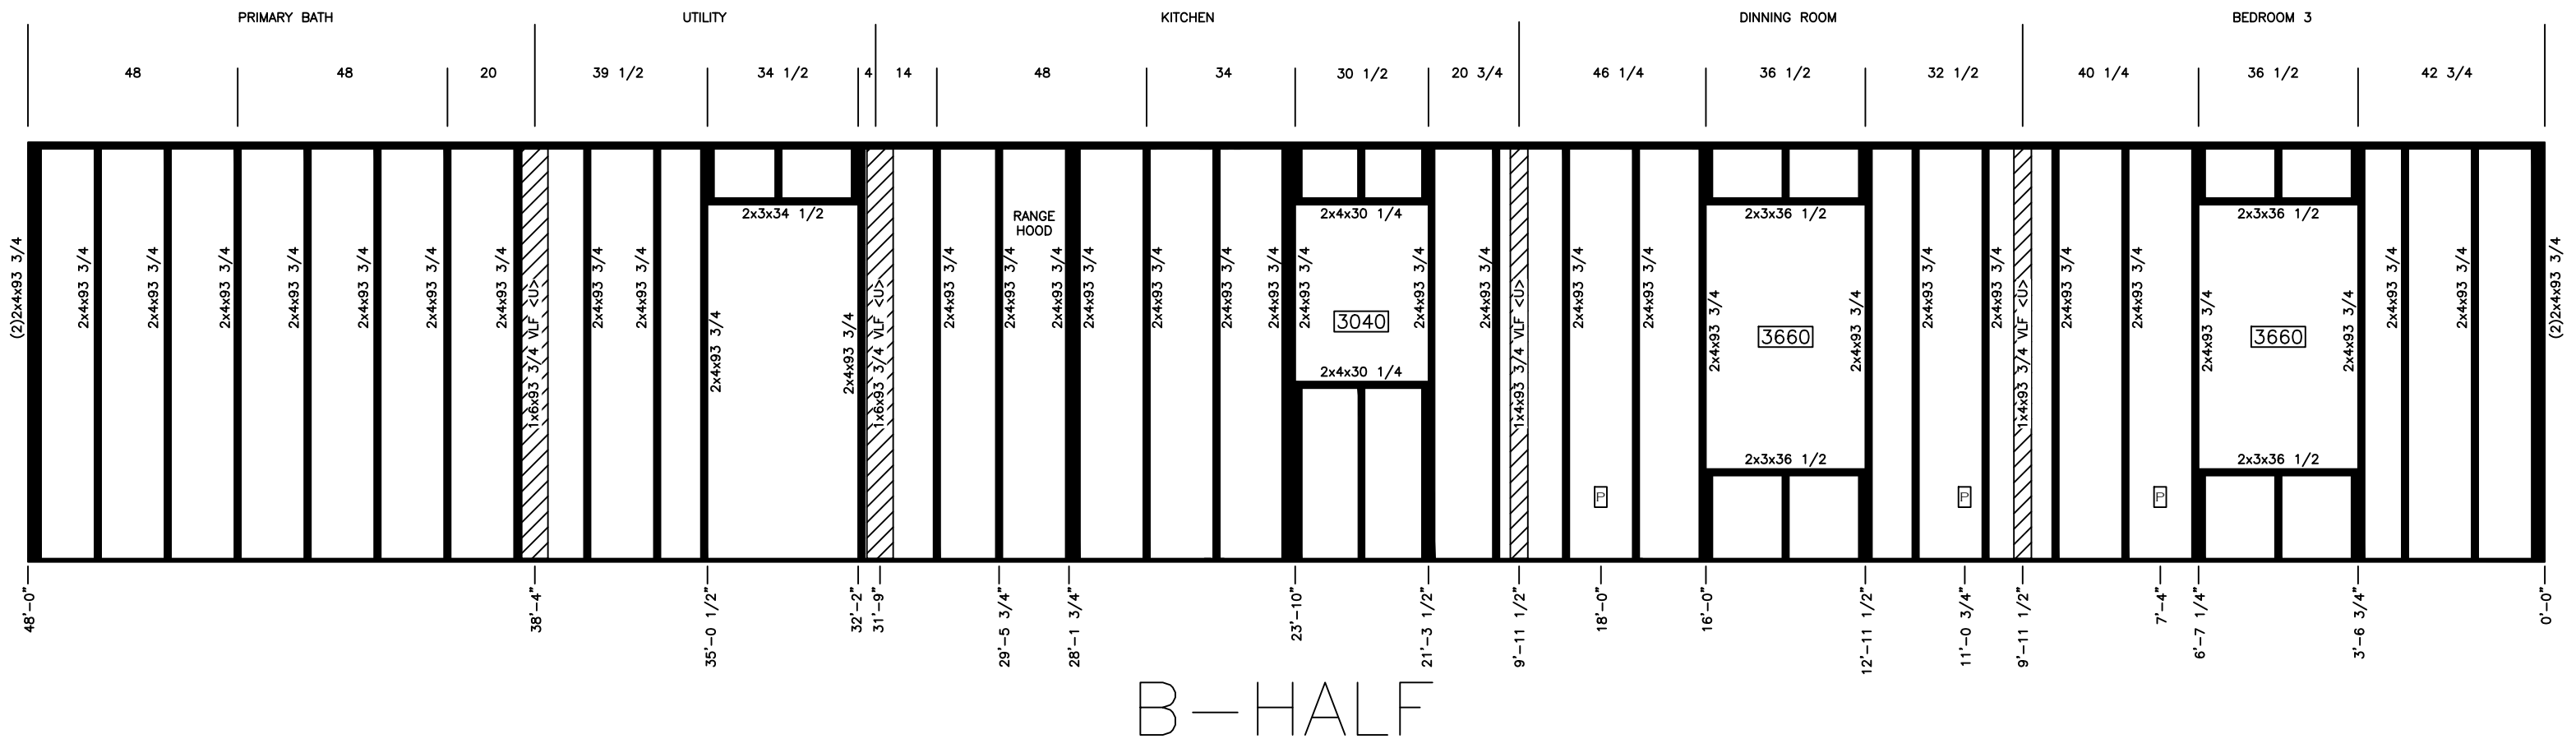

SHEET:	BASE	WALL SET PLAN	 Clayton - 934 1420 Mountain Rd, Andersonville, TN 37705 PH: 865.494.7800 FAX: 865.494.0243	DRAWING # 34M400		MODEL: MOUNTAINEER 48 (28'x48')		STD PLAN *CONDITIONED*: 1,264 FT²	
				MODEL # MTN28483A		SERIES: MOUNTAINEER		REV. BY:	
				DATE: 4/29/2026		SCALE: N.T.S.		PRODUCT DESIGNER: BRIAN K. RIFFEY	
								REV. DATE:	

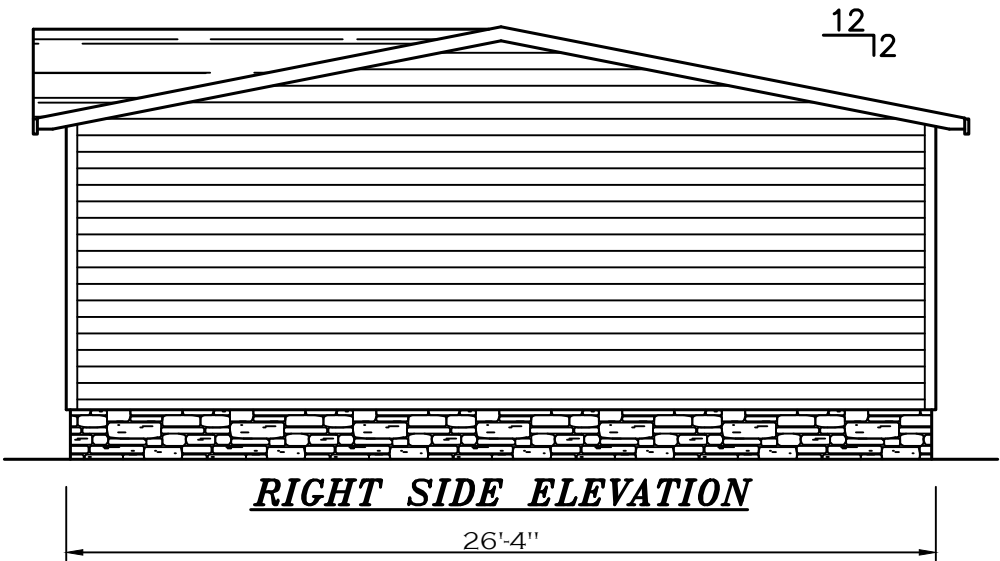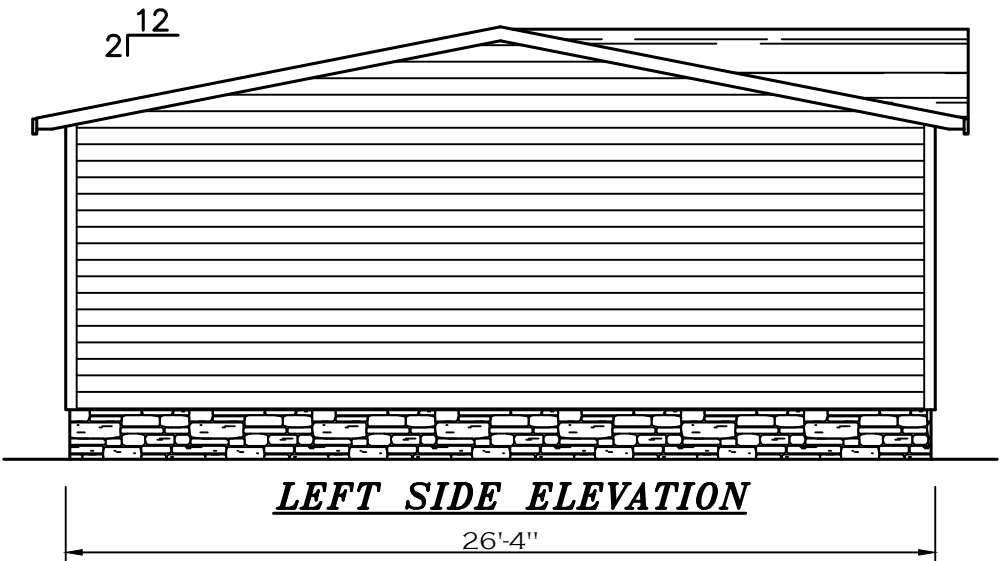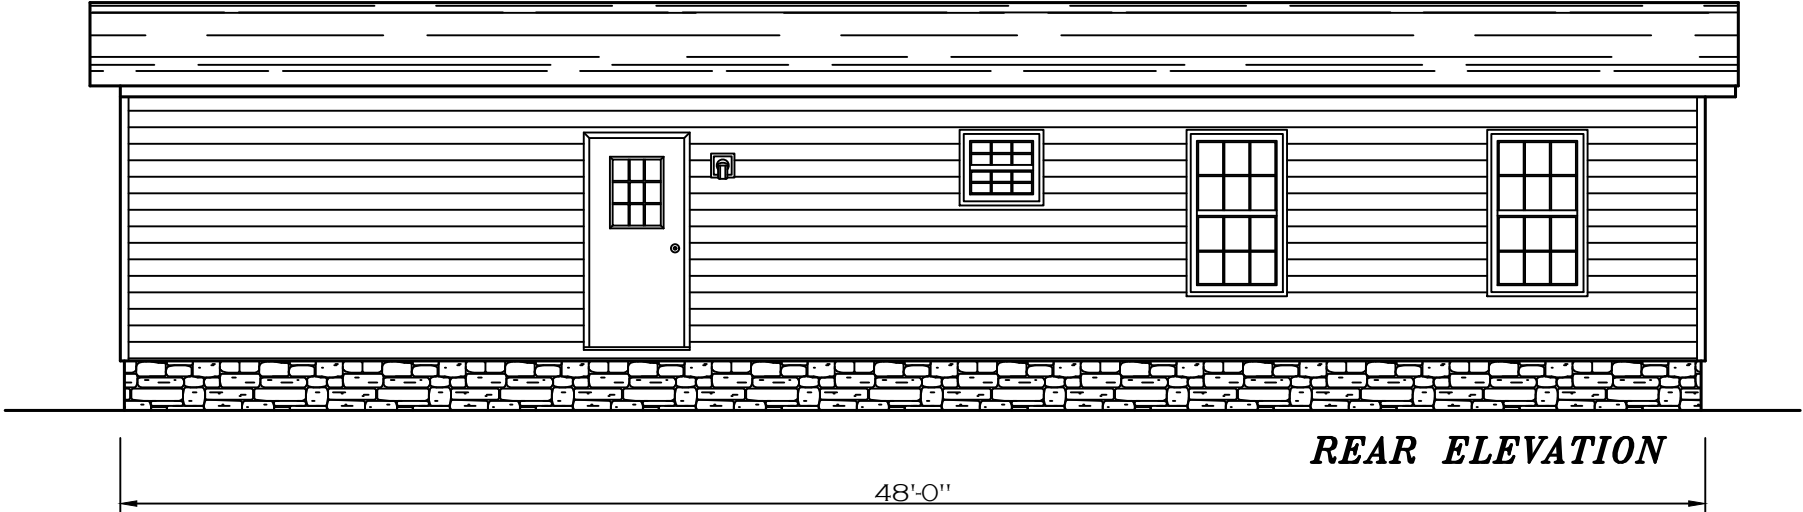

SHEET:
ELEVATION

EXTERIOR
ELEVATIONS

Clayton Clayton - 934
1420 Mountain Rd, Andersonville, TN 37705
PH: 865.494.7800 FAX: 865.494.0243

HILBORN, WERNER, CARTER,
AND ASSOCIATES, INC.
1627 SOUTH MYRTLE AVE.
CLEARWATER, FL. 33756

DRAWING # 34M400
MODEL # MTN28483A
DATE: 4/29/2026 SCALE: N.T.S.

MODEL: MOUNTAINEER 48 (28'x48')
SERIES: MOUNTAINEER
PRODUCT DESIGNER: BRIAN K. RIFFEY

STD PLAN *CONDITIONED*: 1,264 FT²
REV. BY:
REV. DATE: