


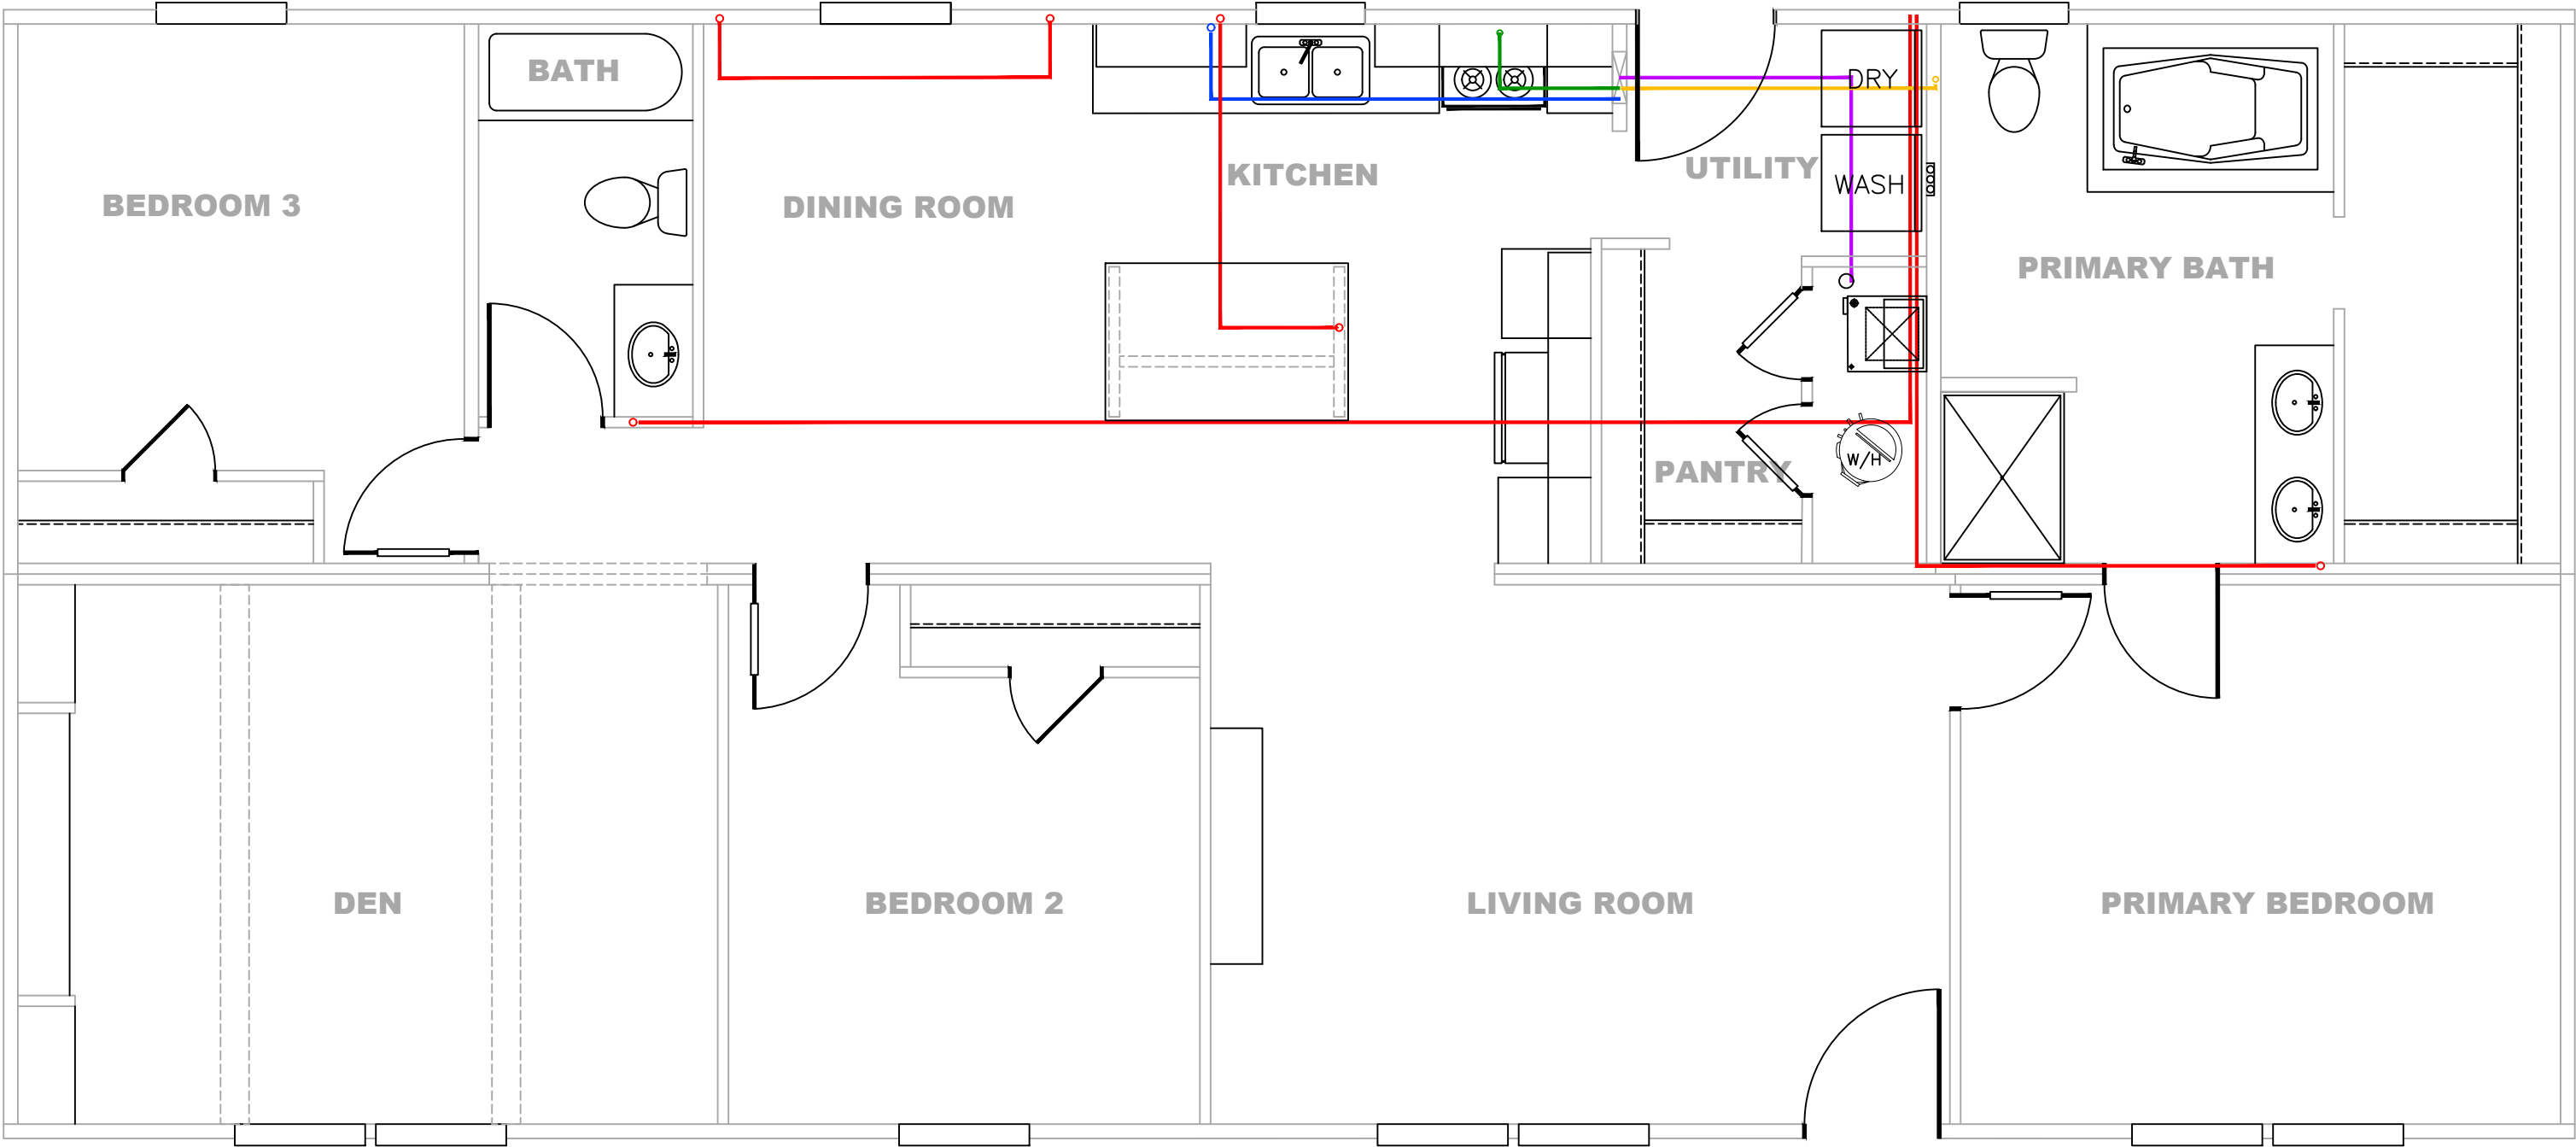

REV #	DATE	DESCRIPTION

SHEET:
FJIG
ELEC

FLOOR JOIST
ELECTRICAL LAYOUT


Clayton Clayton - 934
1420 Mountain Rd, Andersonville, TN 37705
PH: 865.494.7800 FAX: 865.494.0243

HILBORN, WERNER, CARTER,
AND ASSOCIATES, INC.
1627 SOUTH MYRTLE AVE.
CLEARWATER, FL. 33756


DRAWING #:	34M403
MODEL #:	MTN28603A
DATE:	05/20/2026
SCALE:	N.T.S.

MODEL:	MOUNTAINEER (28'x60')
SERIES:	MOUNTAINEER
PRODUCT DESIGNER:	DAMONTE M. FOSTER







STD PLAN *CONDITIONED*:	1,580 FT²
REV. BY:	
REV. DATE:	

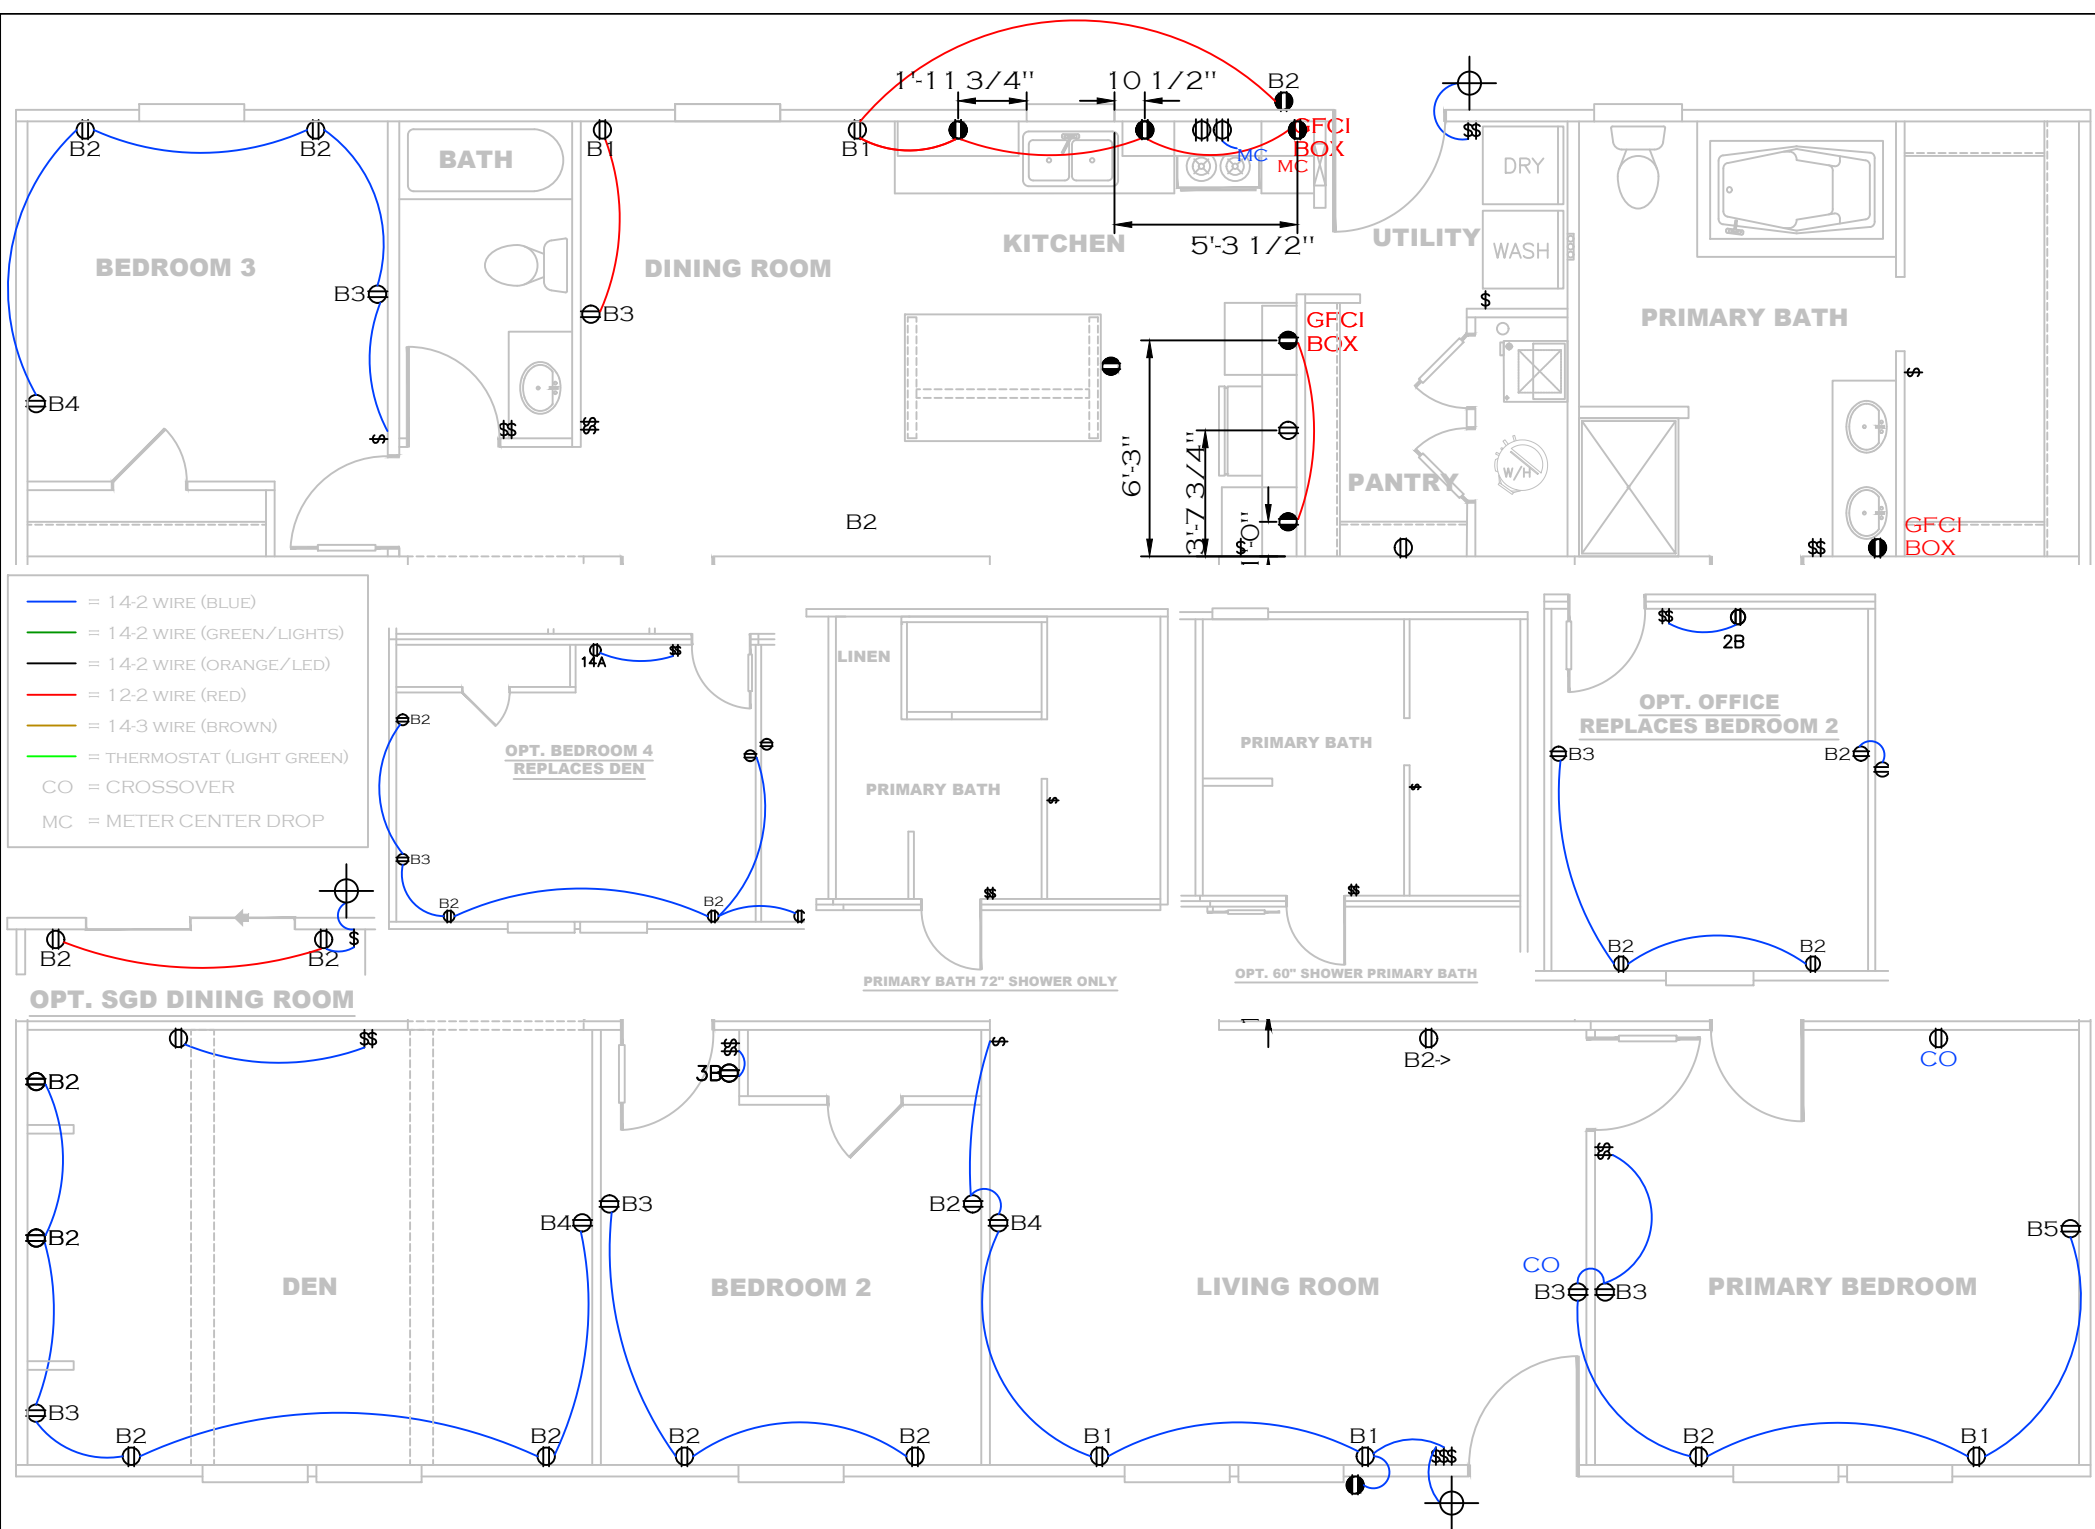


SHEET: BOTTOM	WIRE RUN PLAN	 Clayton - 934 1420 Mountain Rd, Andersonville, TN 37705 PH: 865.494.7800 FAX: 865.494.0243	HILBORN, WERNER, CARTER, AND ASSOCIATES, INC. 1627 SOUTH MYRTLE AVE. CLEARWATER, FL. 33756	DRAWING #: 34M403 MODEL #: MTN28603A DATE: 05/20/2026 SCALE: N.T.S.	MODEL: MOUNTAINEER (28'x60') SERIES: MOUNTAINEER PRODUCT DESIGNER: DAMONTE M. FOSTER	STD PLAN "CONDITIONED": 1,580 FT² REV. BY: REV. DATE:
------------------	---------------	--	---	---	--	---

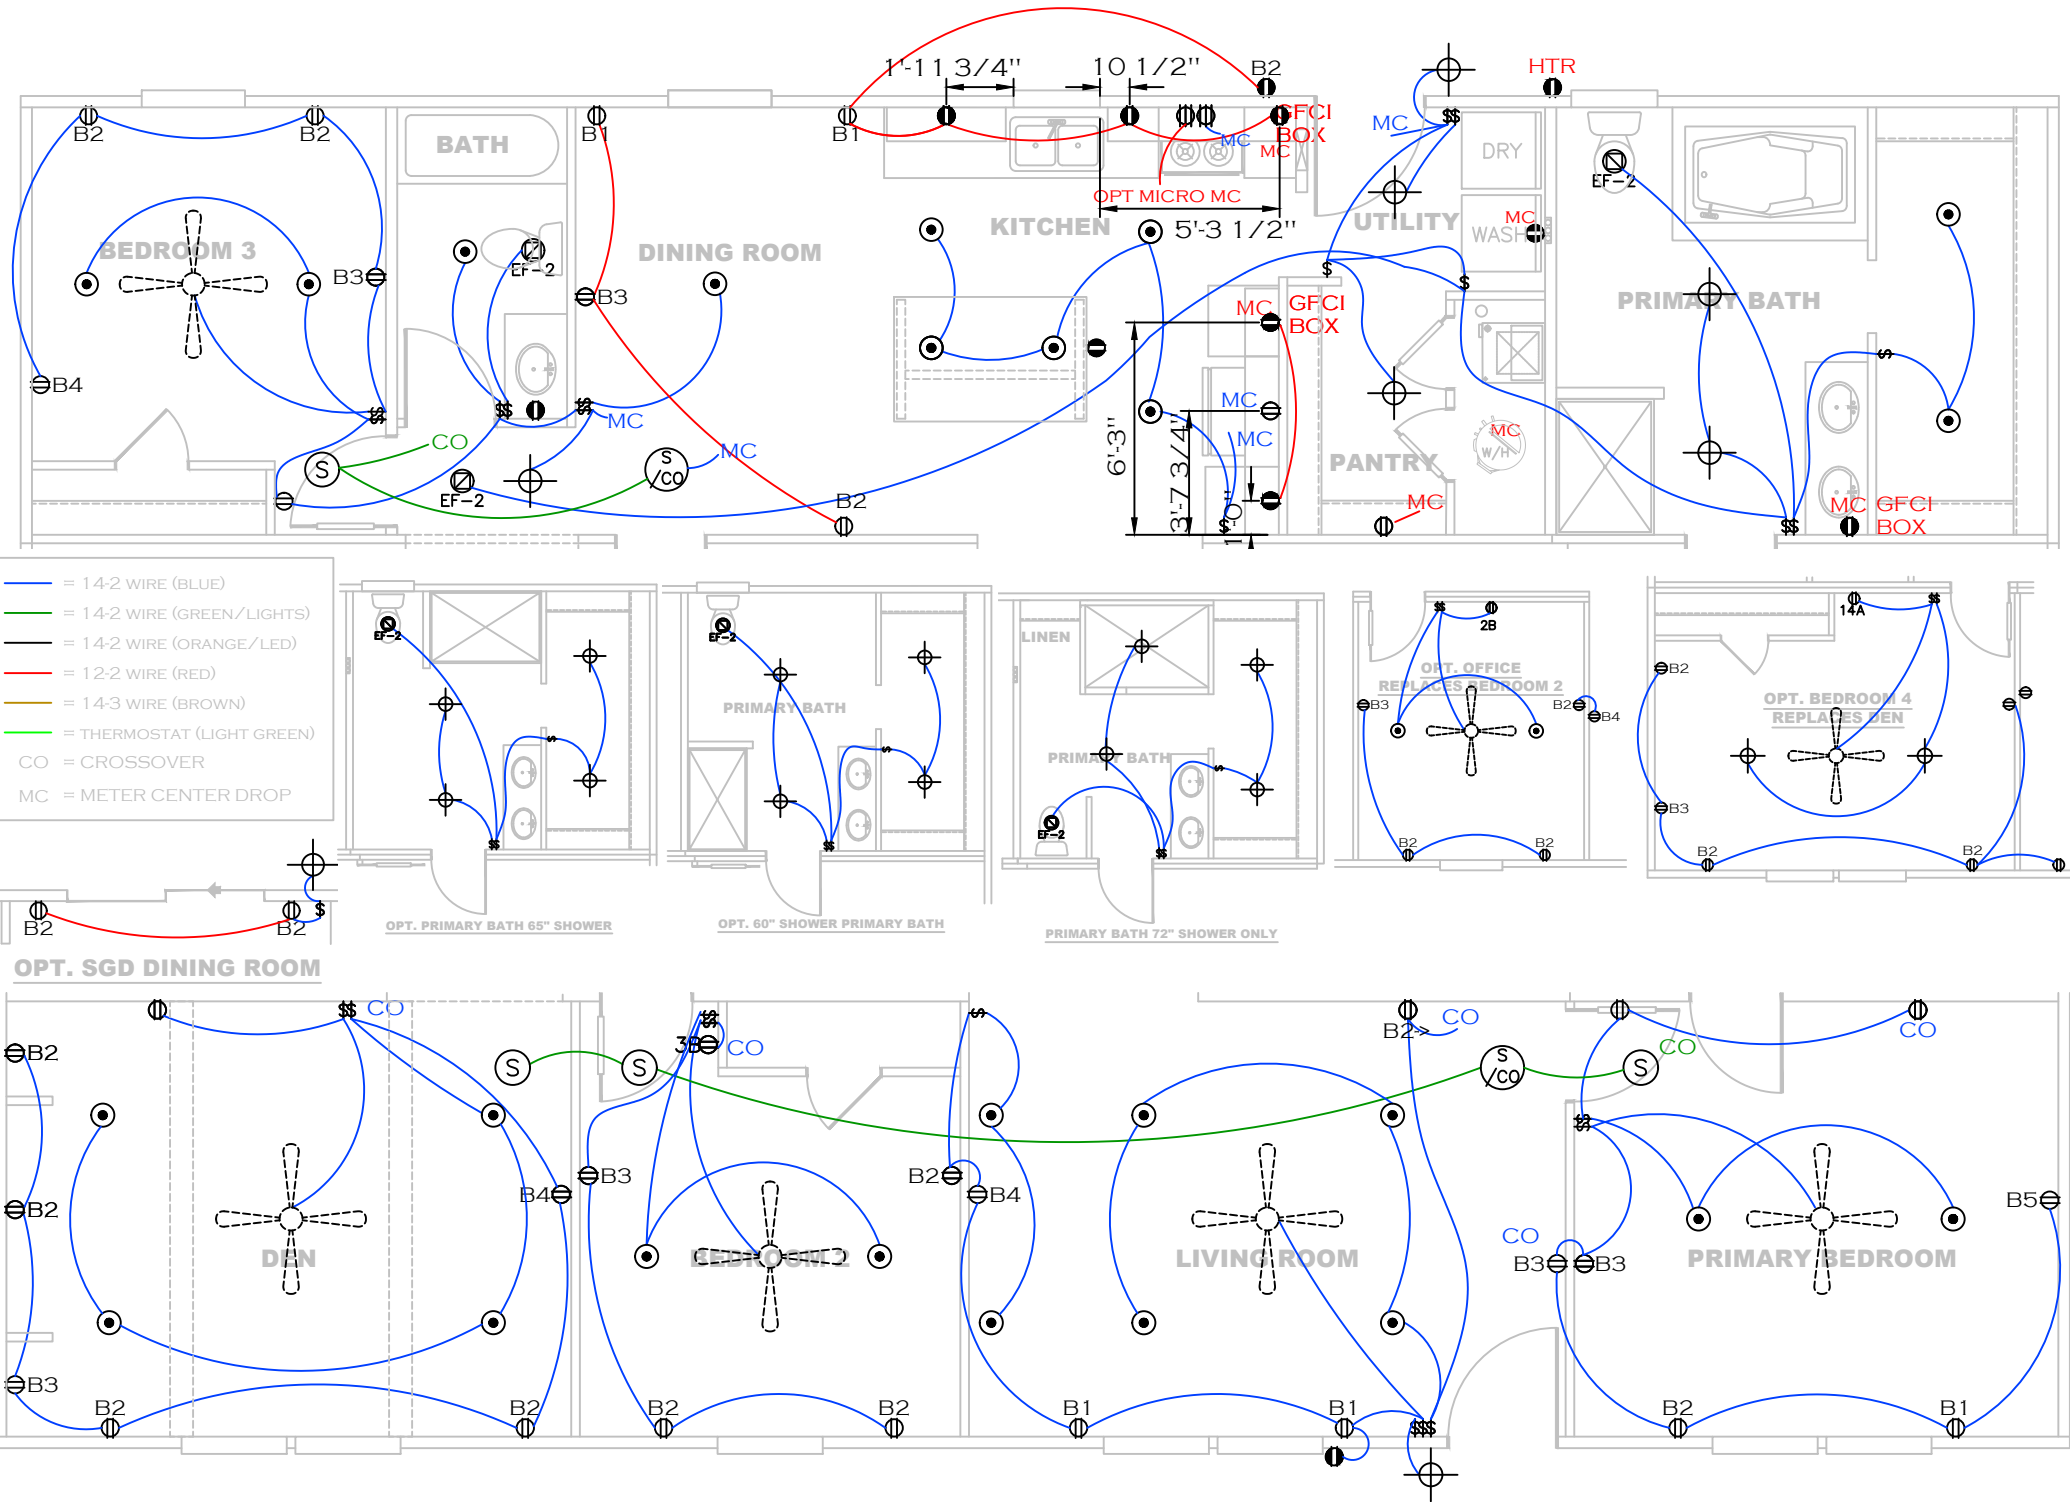

SHEET:	MASTER	WIRE RUN PLAN	 Clayton - 934 1420 Mountain Rd, Andersonville, TN 37705 PH: 865.494.7800 FAX: 865.494.0243	DRAWING #:	34M403	MODEL:	MOUNTAINEER (28'x60')	STD. PLAN "CONDITIONED":	1,580 FT²
				MODEL #:	MTN28603A	SERIES:	MOUNTAINEER	REV. BY:	
				DATE:	05/20/2026	SCALE:	N.T.S.	PRODUCT DESIGNER:	DAMONTE M. FOSTER
								REV. DATE:	

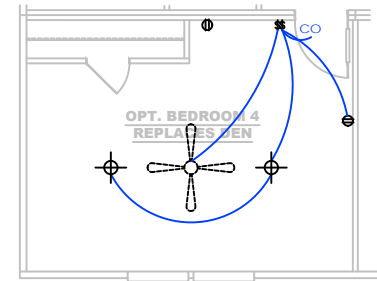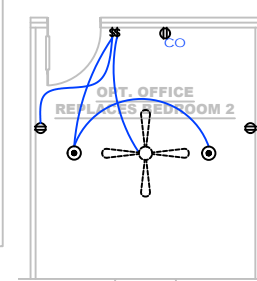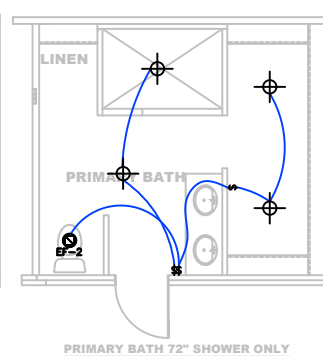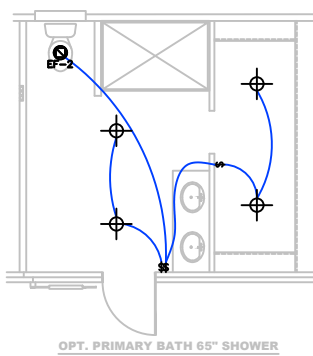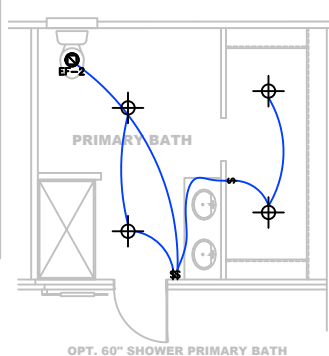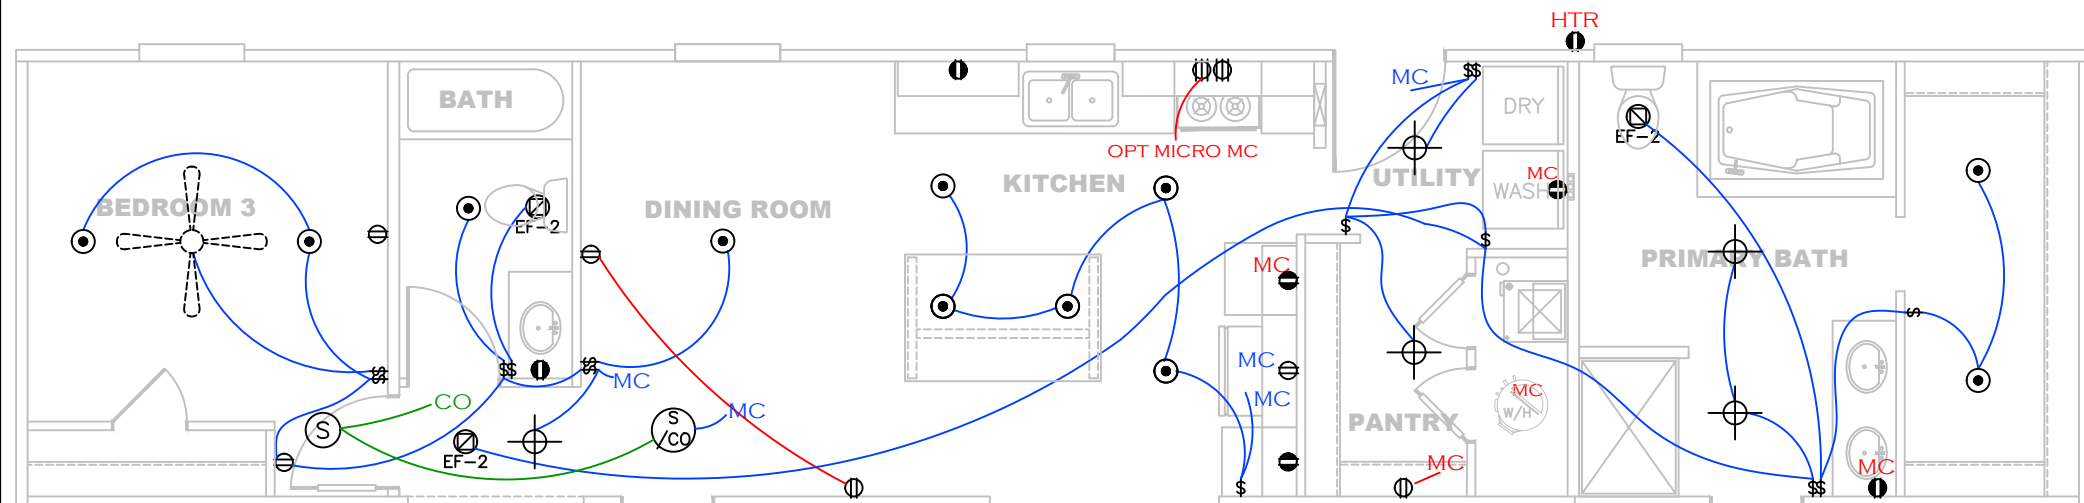

OPT. SGD DINING ROOM

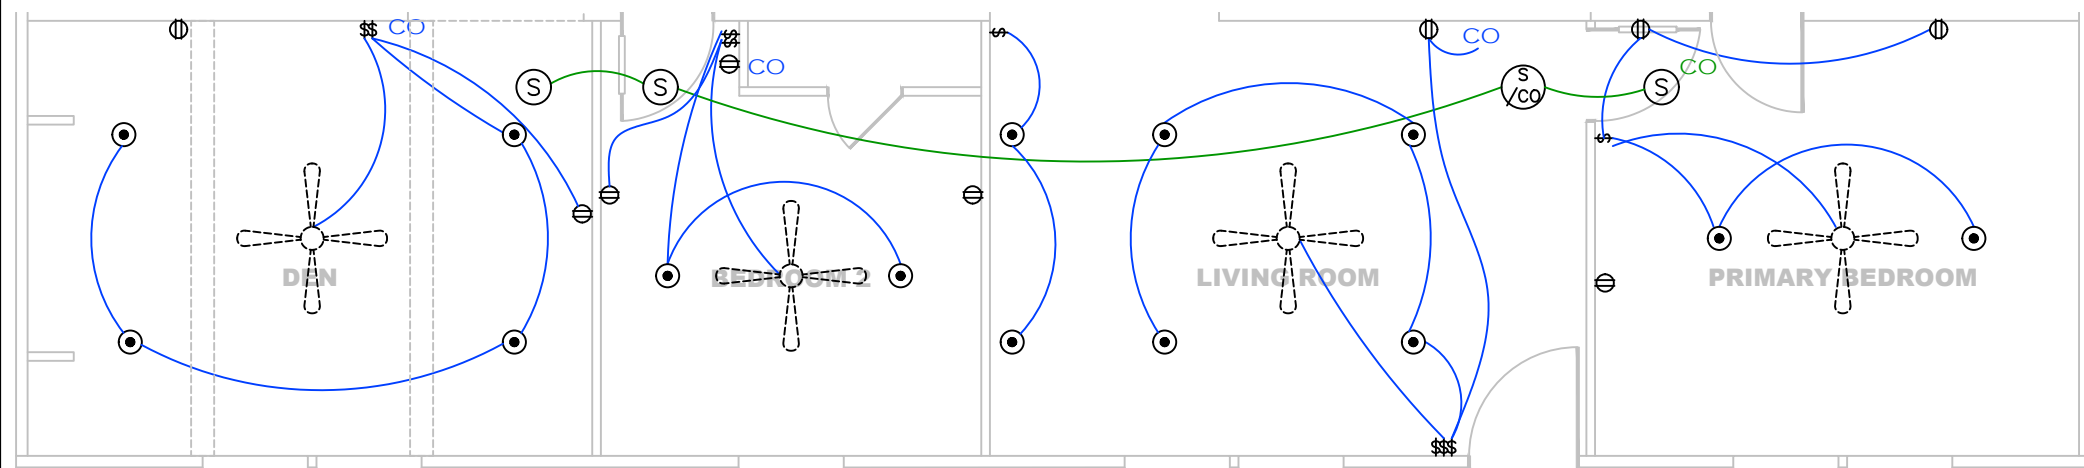

SHEET: TOP	WIRE RUN PLAN	Clayton Clayton - 934 1420 Mountain Rd, Andersonville, TN 37705 PH: 865.494.7800 FAX: 865.494.0243	HILBORN, WERNER, CARTER, AND ASSOCIATES, INC. 1627 SOUTH MYRTLE AVE. CLEARWATER, FL. 33756	DRAWING #: 34M403 MODEL #: MTN28603A DATE: 05/20/2026 SCALE: N.T.S.	MODEL: MOUNTAINEER (28'x60') SERIES: MOUNTAINEER PRODUCT DESIGNER: DAMONTE M. FOSTER	STD PLAN "CONDITIONED": 1,580 FT² REV. BY: REV. DATE:
---------------	---------------	---	---	---	--	---